

- NOTES:**
1. ALL DIMENSIONS IN MILLIMETRES (mm) AND ALL LEVELS IN METRES ADD UNLESS SHOWN OTHERWISE.
 2. ALL CHANGES ARE IN METRES (m) AND ALL LEVELS IN METRE ABOVE ORDNANCE DATUM (mAOD).
 3. DRAWING TO BE READ IN CONJUNCTION WITH RELEVANT SPECIFICATION AND ALL OTHER RELEVANT DRAWINGS.

LEGEND:

- EXISTING GROUND PROFILE (EGL)
- FINISHED GROUND PROFILE (FGL)

REFERENCES

- 5037610000-WR-DRA-04190100 PLANNING DRAWING - LOCATION PLAN
- 5037610000-WR-DRA-04190101 PLANNING DRAWING - EXISTING SITE PLAN
- 5037610000-WR-DRA-04190102 PLANNING DRAWING - EXISTING SITE SECTIONS SHEET 1 OF 2
- 5037610000-WR-DRA-04190103 PLANNING DRAWING - EXISTING SITE SECTIONS SHEET 2 OF 2
- 5037610000-WR-DRA-04190104 PLANNING DRAWING - PROPOSED SITE PLAN
- 5037610000-WR-DRA-04190106 PLANNING DRAWING - PROPOSED SECTIONAL ELEVATIONS SHEET 2 OF 2
- 5037610000-WR-DRA-04190107 PLANNING DRAWING - PROPOSED ACCESS LAYOUT PLAN SHEET 1 OF 2
- 5037610000-WR-DRA-04190108 PLANNING DRAWING - PROPOSED ACCESS LAYOUT PLAN SHEET 2 OF 2
- 5037610000-WR-DRA-04190109 PLANNING DRAWING - PROPOSED DRAINAGE LAYOUT PLAN

CURRENT ISSUE INFORMATION:

OB	FOR INFORMATION	YS	EM	ER	25.03.20
0A	FOR INFORMATION	RT	EM	ER	20.03.20
Rev	Description	Drawn	Chk'd	App'd	Date

This drawing is the property of Scottish Water and must not be copied or used for any purpose other than that for which it is supplied without the written consent of Scottish Water.

Scottish Water
Trusted to serve Scotland

SCOTTISH WATER
CASTLE HOUSE
6 CASTLE DRIVE
CARNegie CAMPUS
DUNFERMLINE
FIFE KY11 8GG
TEL: 0800 0778778

amey


PRECISION HOUSE,
MCNEIL DRIVE,
EUROCENTRAL,
MOTHERWELL,
ML1 4JR

Originated By	Drawn By	Checked By	Approved By
ER	RT	EM	ER
Date	Date	Date	Date
17.03.20	18.03.20	20.03.20	20.03.20
Scale	Status		
1:250	FOR PLANNING		


Project Title
BONNYCRAIG WTW

Drawing Title
**PLANNING DRAWING
PROPOSED SECTIONAL ELEVATIONS
SHEET 1 OF 2**


ELLIPSE EQUIPMENT No.
ELLIPSE PLANT No. AUTOCODE No. 503761
Drawing No.
503761000-WR-DRA-04190105-0B

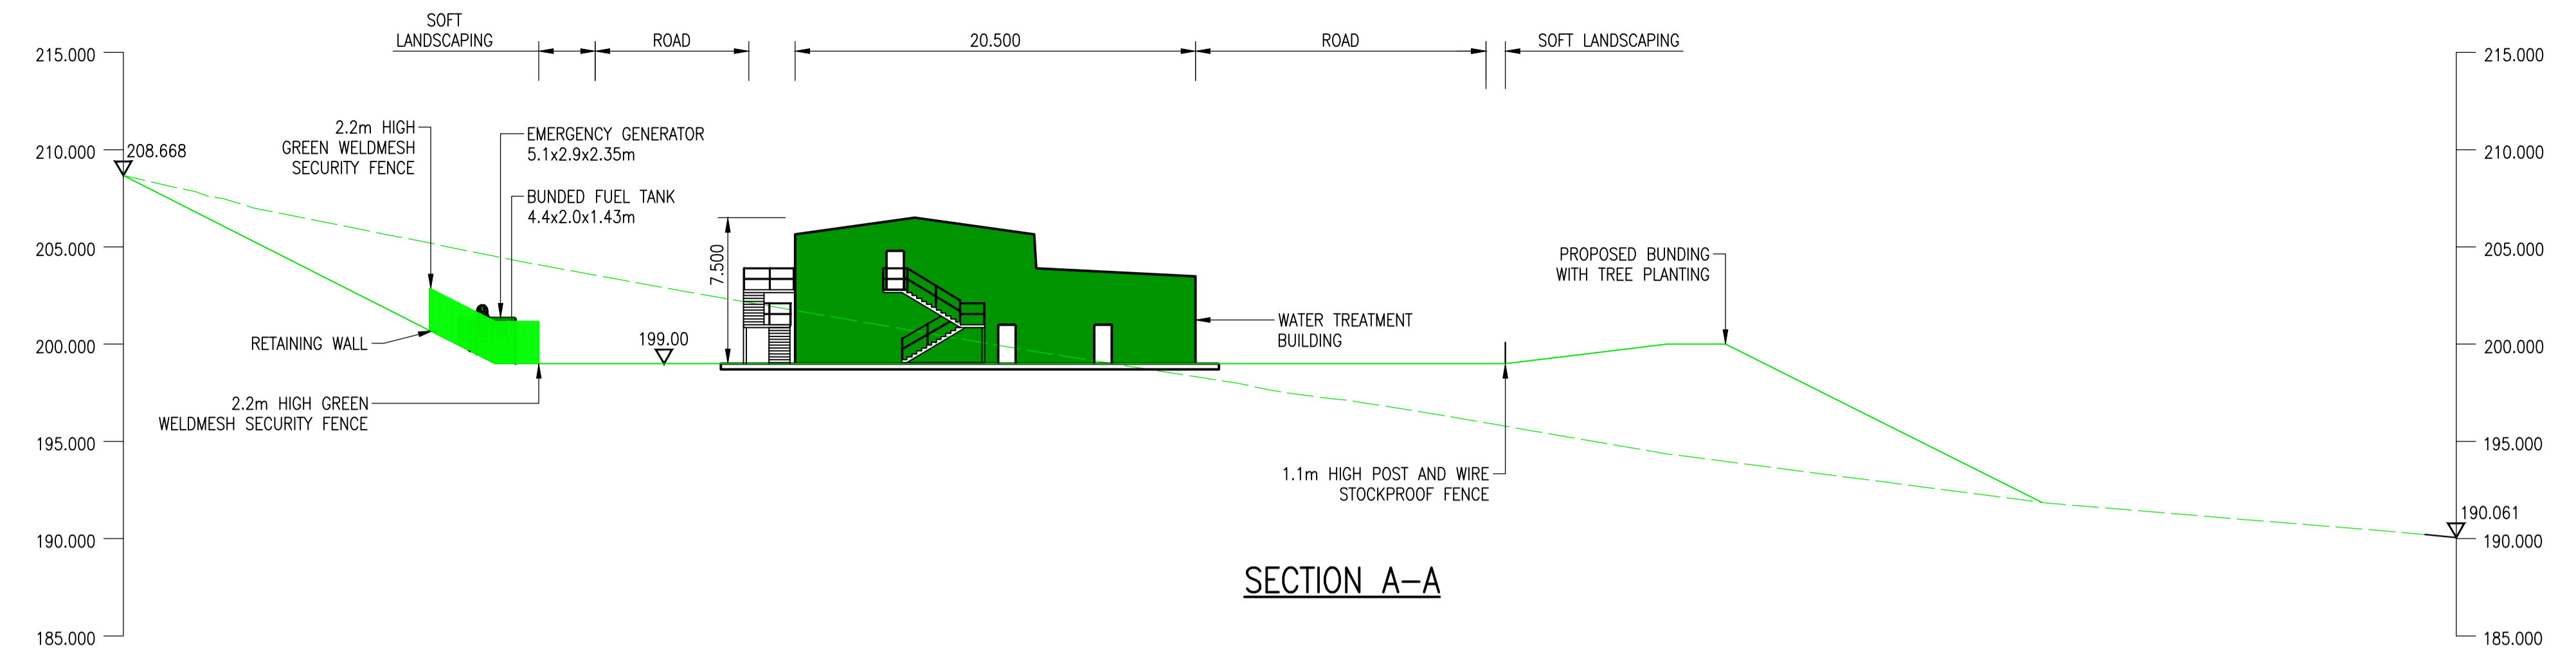


SECTION A-A

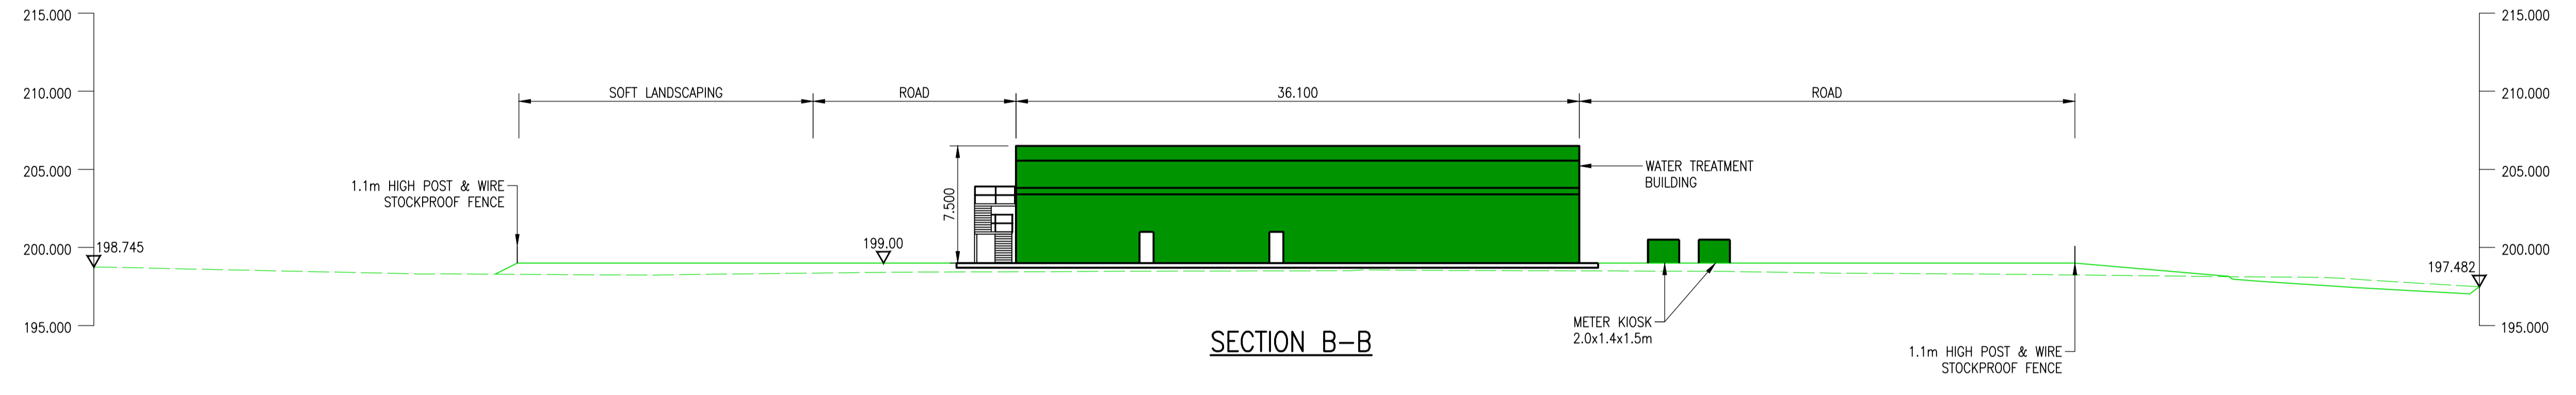

SECTION B-B

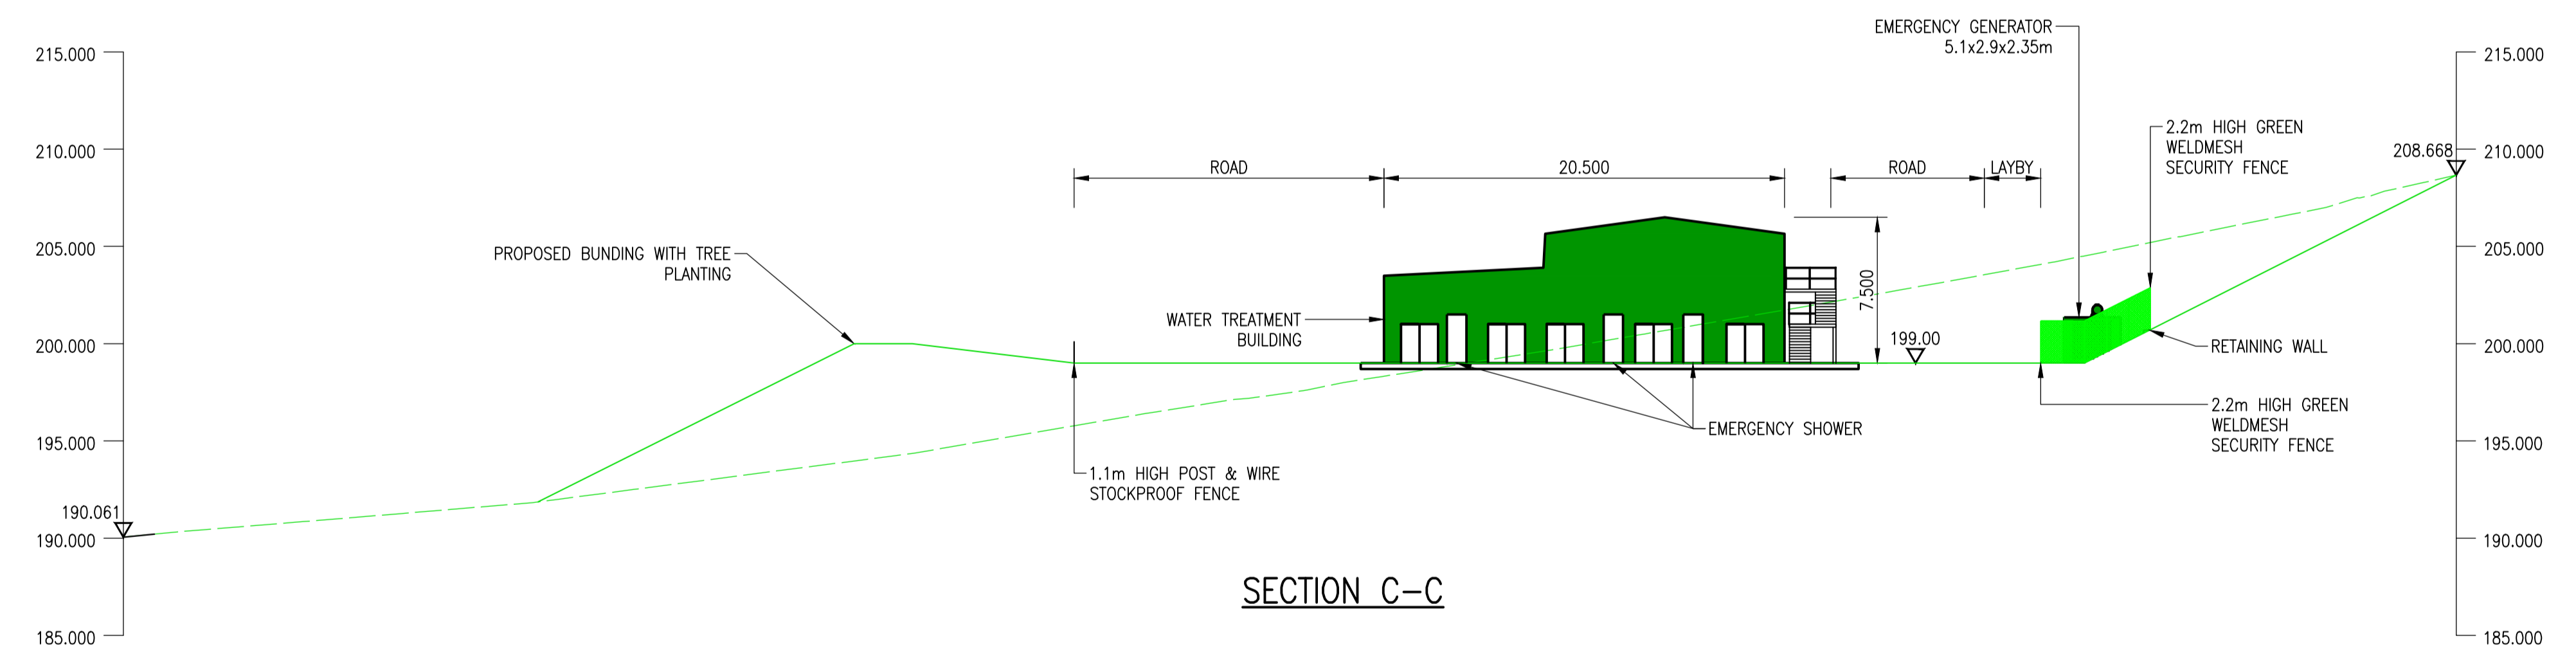

SECTION C-C

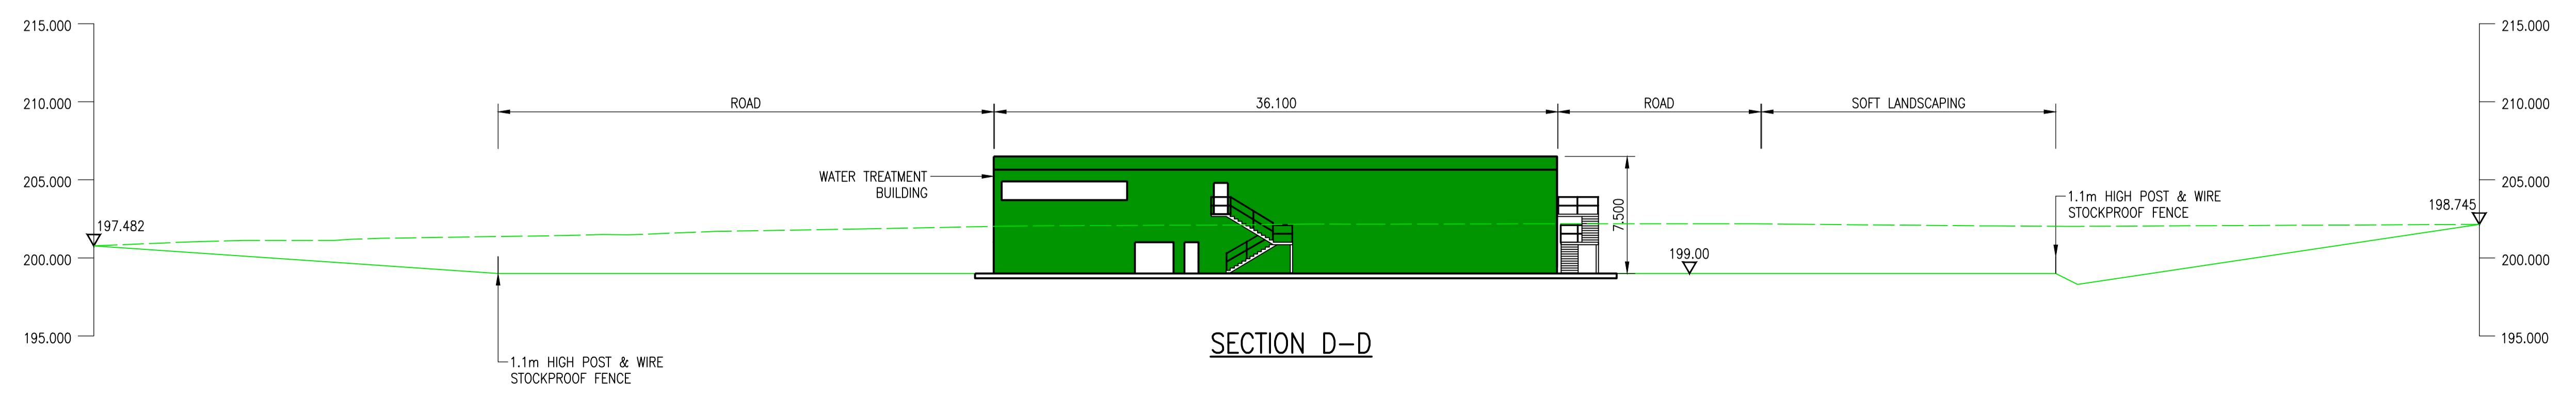

SECTION D-D

