






 
 




- Notes:
- ALL DIMENSIONS IN MILLIMETRES AND ALL LEVELS IN METRES UNLESS SHOWN OTHERWISE.
  - ALL DIMENSIONS AND LEVELS TO BE CHECKED ON SITE AND ANY DISCREPANCIES IDENTIFIED SHOULD BE REPORTED TO THE DESIGN ENGINEER PRIOR TO COMMENCEMENT OF WORK.
  - ALL LEVELS IN METRES (m) ABOVE ORDNANCE DATUM (AOD).

NEW WORKS LEGEND:  
 PLANNING APPLICATION BOUNDARY  
 AREA = 7634m<sup>2</sup>

- EXISTING SERVICES LEGEND:
-  SEWER - COMBINED (WITH MANHOLE)
  -  WATER MAIN - POTABLE
  -  GLP - GAS MAIN - LOW PRESSURE
  -  GMP - GAS MAIN - MEDIUM PRESSURE
  -  LV - ELECTRIC - LOW VOLTAGE
  -  EHV - ELECTRIC - EXTRA HIGH VOLTAGE
  -  CATV - CABLE TV

LOCATION OF EXISTING SERVICES SHOWN ARE FROM PIR DATA PROVIDED AND UNCONFIRMED

- GENERAL LEGEND:
-  DONALD RODGER ASSOCIATES LTD EXISTING TREES SURVEY AND TREE Nr.
  -  CANOPY
  -  ROOT EXTENTS

- REFERENCES:
- DOA0024560-SN-DRA-04000101 PROPOSED ATTENUATION TANK LOCATION PLAN FOR PLANNING
  - DOA0024560-SN-DRA-04000102 PROPOSED ATTENUATION TANK SITE LAYOUT FOR PLANNING
  - DOA0024560-SN-DRA-04000103 PROPOSED ATTENUATION TANK SITE ELEVATIONS FOR PLANNING
  - DOA0024560-SN-DRA-04000104 PROPOSED ATTENUATION TANK PLAN FOR PLANNING
  - DOA0024560-SN-DRA-04000105 PROPOSED ATTENUATION TANK ELEVATIONS FOR PLANNING
  - DOA0024560-SN-DRA-04000106 PROPOSED MCC KIOSK GA FOR PLANNING

Rev	Description	Drawn	Chk'd	App'd	Date
OB	For Information	SJF	GDH	GDH	01-Feb-22
0A	For Information	SJF	CMcN	GDH	13-Sep-21

This drawing is the property of Scottish Water and must not be copied or used for any purpose other than that for which it is supplied without the written consent of Scottish Water.

SCOTTISH WATER  
 CASTLE HOUSE  
 6 CASTLE HOUSE  
 CARNegie CAMPUS  
 DUNFERMLINE  
 FIFE KY11 8GG  
 TEL: 01383 848200  
 FAX: 01383 848371


CALEDONIA WATER ALLIANCE  
 1<sup>st</sup> FLOOR, BUCHANAN TOWER  
 BUCHANAN BUSINESS PARK  
 CUMBERNAULD ROAD, STEPPS  
 GLASGOW G33 6HZ  
 TEL: 0141 212 6610


Originated By	Drawn By	Checked By	Approved By
SJF	SJF	CMcN	GDH
Date	Date	Date	Date
13-Sep-21	13-Sep-21	13-Sep-21	13-Sep-21
Scale	Status		
1:200	FOR INFORMATION		

Project Title  
**MARCHMONT ROAD  
 WARRENDER PARK ROAD EDINBURGH**

Drawing Title  
**EXISTING SITE PLAN  
 FOR PLANNING**

ELLIPSE EQUIPMENT No. AAAAAAAAAA  
 ELLIPSE PLANT No. XXXXXXXXXX | AUTOCODE No. 503594  
 Drawing No.  
**DOA0024560-SN-DRA-04000107-0B**

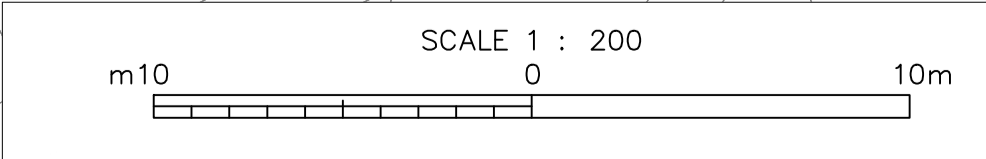

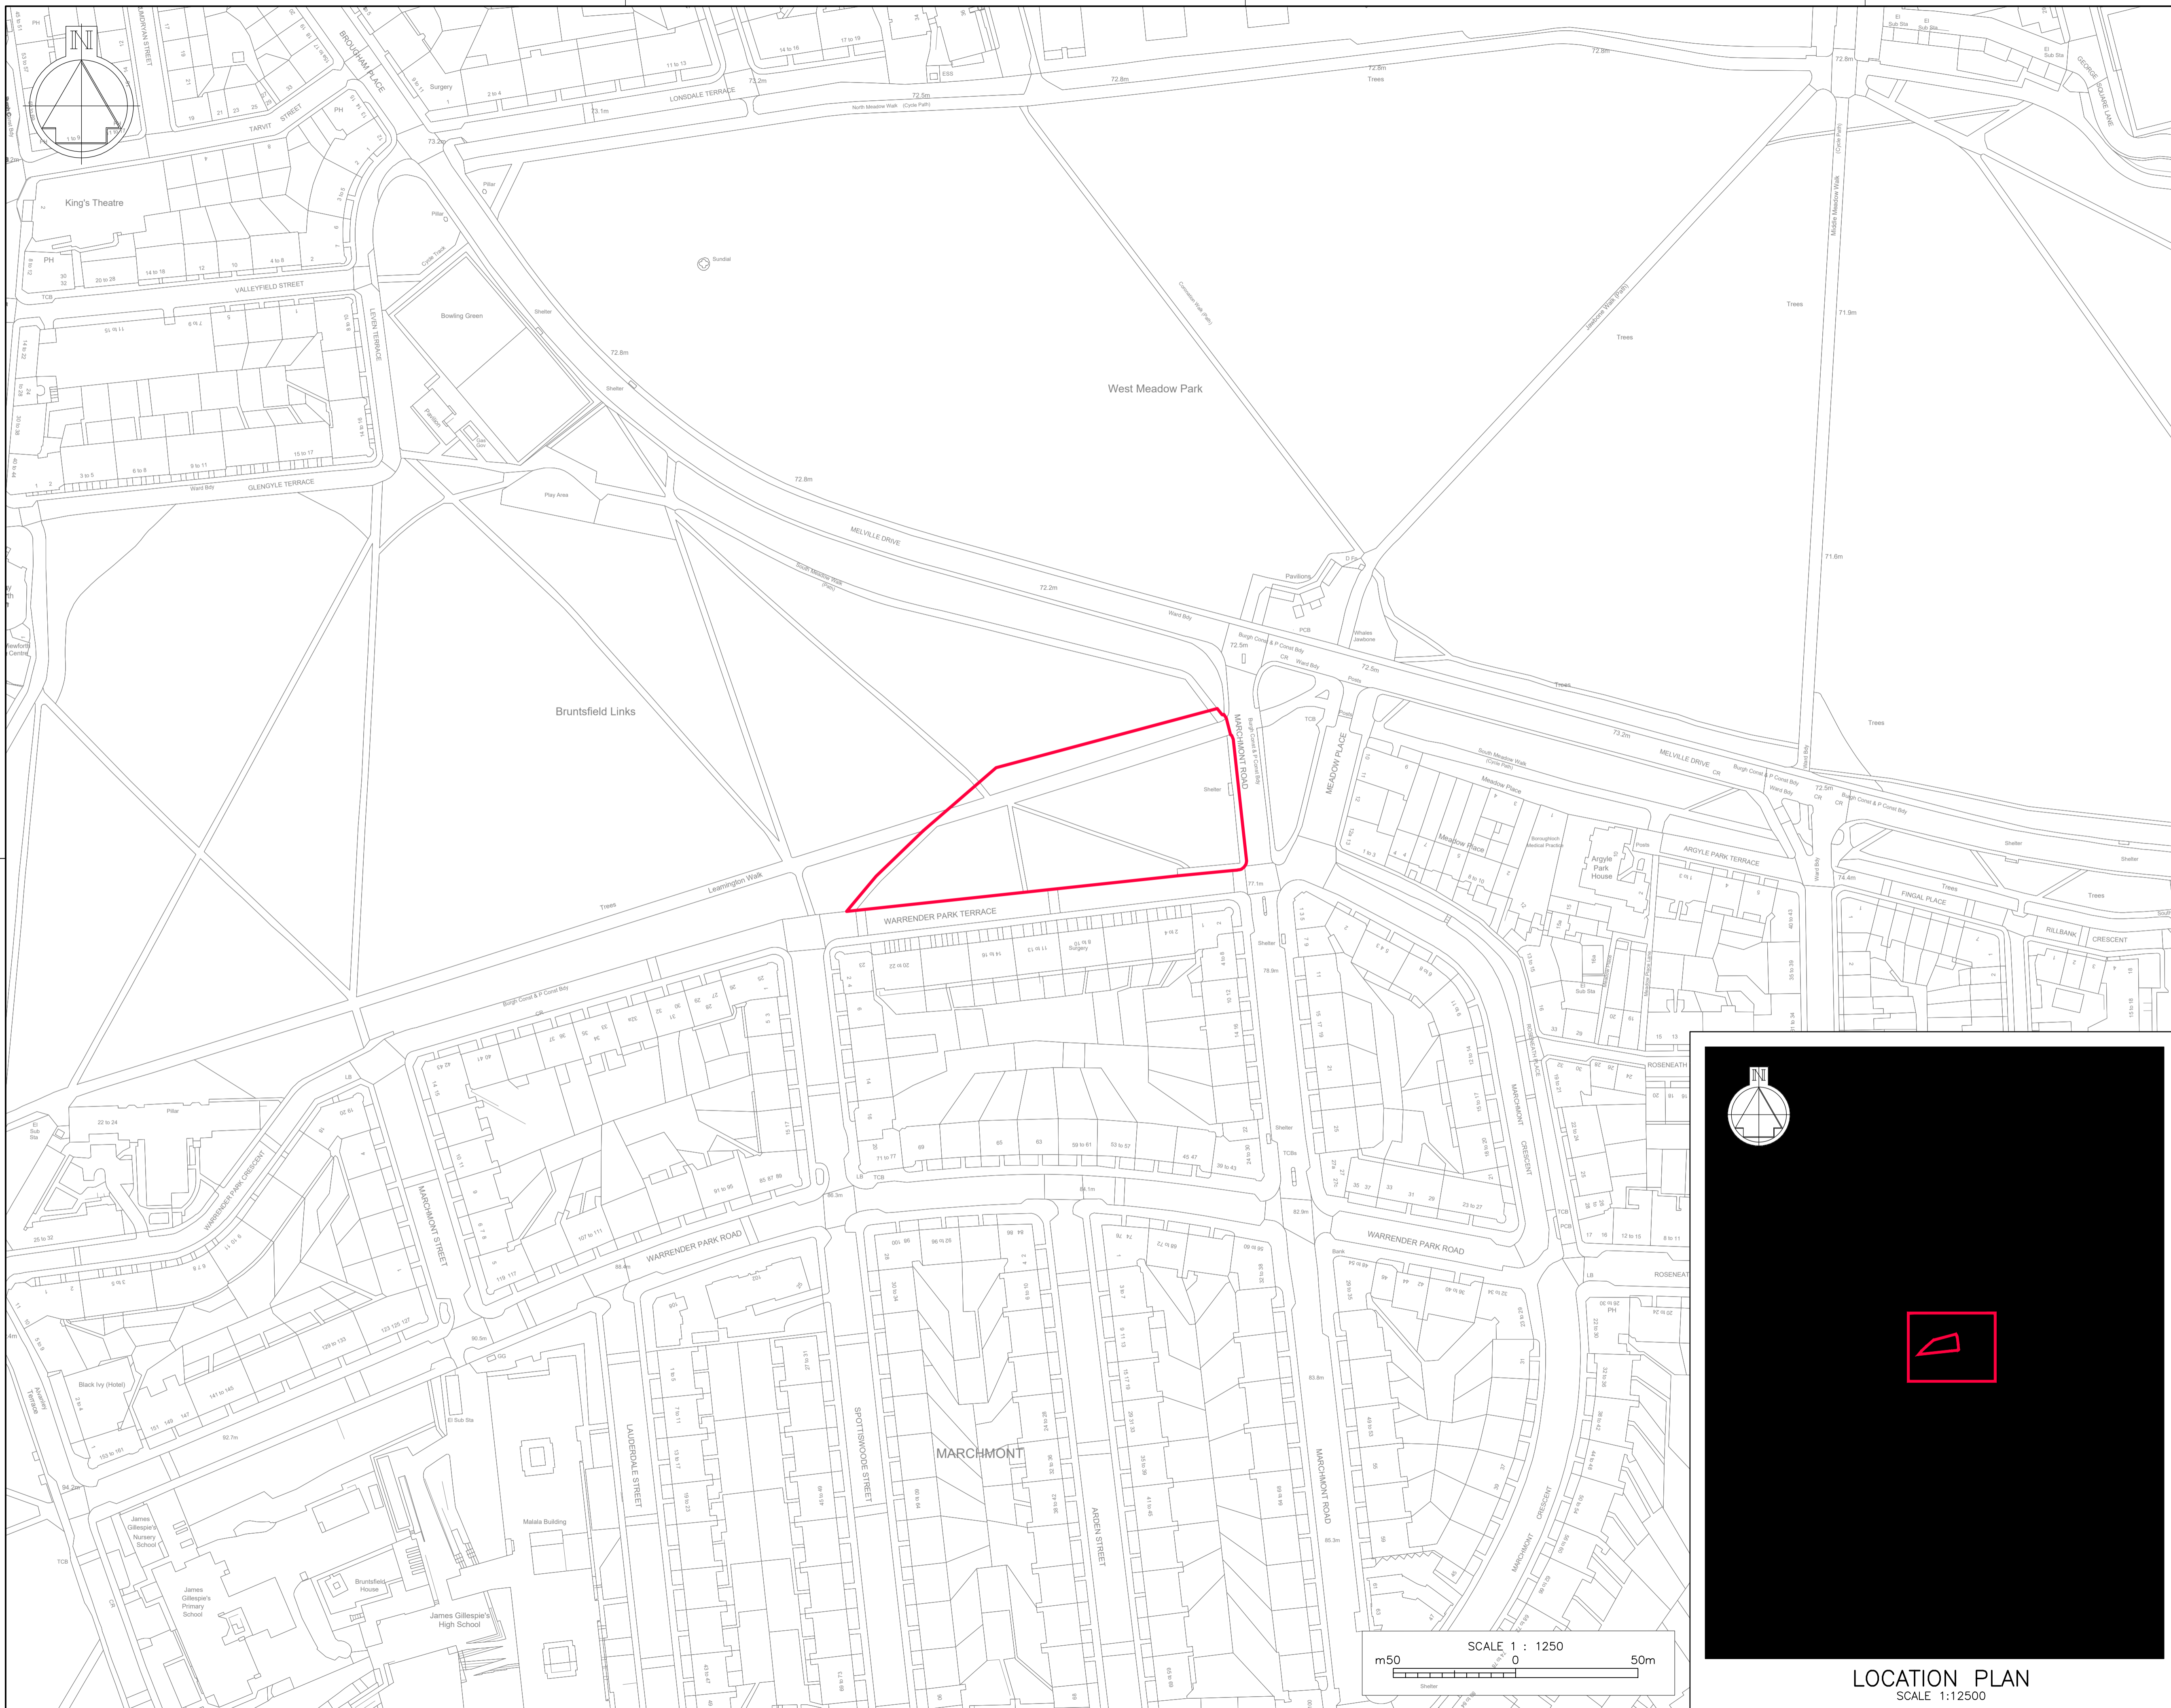

- Notes:**
- ALL DIMENSIONS IN MILLIMETRES AND ALL LEVELS IN METRES UNLESS SHOWN OTHERWISE.
  - ALL DIMENSIONS AND LEVELS TO BE CHECKED ON SITE AND ANY DISCREPANCIES IDENTIFIED SHOULD BE REPORTED TO THE DESIGN ENGINEER PRIOR TO COMMENCEMENT OF WORK.
  - ALL LEVELS IN METRES (m) ABOVE ORDNANCE DATUM (AOD).

**LEGEND:**

PLANNING APPLICATION BOUNDARY  
AREA = 7634m<sup>2</sup>

**REFERENCES:**

DOA0024560-SN-DRA-04000102  
PROPOSED ATTENUATION TANK SITE PLAN FOR PLANNING  
DOA0024560-SN-DRA-04000103  
PROPOSED ATTENUATION TANK SITE ELEVATIONS FOR PLANNING  
DOA0024560-SN-DRA-04000104  
PROPOSED ATTENUATION TANK PLAN FOR PLANNING  
DOA0024560-SN-DRA-04000105  
PROPOSED ATTENUATION TANK ELEVATIONS FOR PLANNING  
DOA0024560-SN-DRA-04000106  
PROPOSED MCC KIOSK GA FOR PLANNING

OC	For Information	SJF	GDH	GDH	01-Feb-22
OB	For Information	SJF	CMcN	CMcN	21-Jun-21
OA	For Information	SJF	CMcN	GDH	21-Jun-21
Rev	Description	Drawn	Chk'd	App'd	Date

This drawing is the property of Scottish Water and must not be copied or used for any purpose other than that for which it is supplied without the written consent of Scottish Water.

**SCOTTISH WATER**  
CASTLE HOUSE  
6 CASTLE HOUSE  
CARNegie CAMPUS  
DUNFERMLINE  
FIFE KY11 8GG  
TEL: 01383 848200  
FAX: 01383 848371

CALEDONIA WATER ALLIANCE  
11 FLOOR, BUCHANAN TOWER  
BUCHANAN BUSINESS PARK  
CUMBERNAULD ROAD, STEPPS  
GLASGOW G33 6HZ  
TEL: 0141 212 6610



Originated By	Drawn By	Checked By	Approved By
SJF	SJF	CMcN	GDH
Date	Date	Date	Date
02-Jun-21	18-Jun-21	21-Jun-21	21-Jun-21
Scale	Status		
1:1250	FOR INFORMATION		

**Project Title**  
MARCHMONT ROAD  
WARRENDER PARK ROAD EDINBURGH

**Drawing Title**  
PROPOSED ATTENUATION TANK  
LOCATION PLAN  
FOR PLANNING

ELLIPSE EQUIPMENT No: AAAAAAAAAA  
ELLIPSE PLANT No: XXXXXXXXXX | AUTOCODE No: 503594

Drawing No.  
**DOA0024560-SN-DRA-04000101-0C**

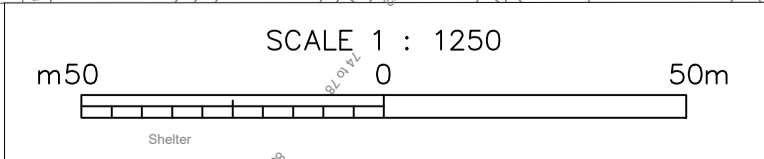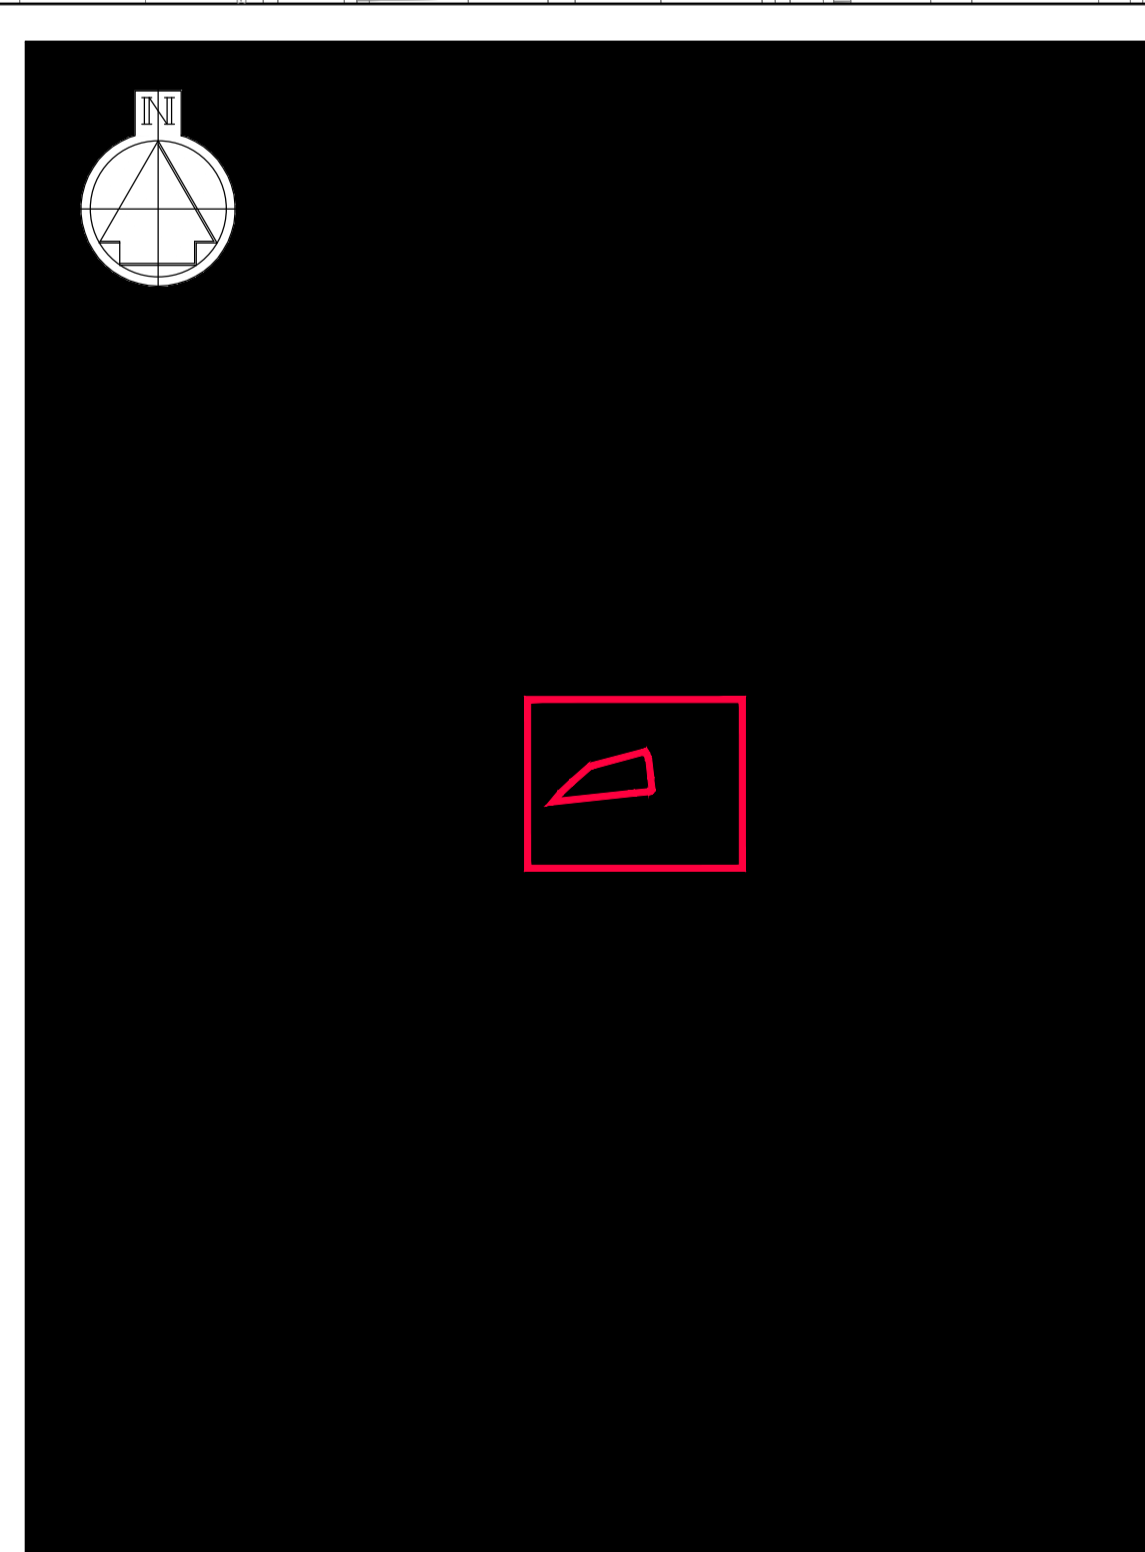

**LOCATION PLAN**  
SCALE 1:12500

- Notes:**
1. ALL DIMENSIONS IN MILLIMETRES AND ALL LEVELS IN METRES UNLESS SHOWN OTHERWISE.
  2. ALL DIMENSIONS AND LEVELS TO BE CHECKED ON SITE AND ANY DISCREPANCIES IDENTIFIED SHOULD BE REPORTED TO THE DESIGN ENGINEER PRIOR TO COMMENCEMENT OF WORK.
  3. ALL LEVELS IN METRES (m) ABOVE ORDNANCE DATUM (AOD).
  4. EXISTING GROUNDS TO BE REINSTATED TO THEIR EXISTING LINE & LEVEL UPON COMPLETION OF WORKS.
  5. ELECTRICITY RUN FROM EXISTING KIOSK LOCATION TO TANK TO BE HAND DUG IN ANY ROOT PROTECTION AREA (RPA) AND ROUTED TO EXIT RPA AT CLOSEST POINT.
  6. NEW PIPES FROM MARCHMONT RD TO PROPOSED STORAGE TANK TO BE INSTALLED USING TRENCHLESS TECHNOLOGY WITHIN THE RPA WITH FEEDER PIT SITUATED IN THE ROAD OR FOOTPATH OF MARCHMONT RD AND THE RECEIVING PIT BEYOND THE RPA UNLESS OTHERWISE AGREED WITH PLANNING AUTHORITY.

- NEW WORKS LEGEND:**
- PLANNING APPLICATION BOUNDARY AREA = 7634m<sup>2</sup>
  - BELOW GROUND STRUCTURES
  - ACCESS COVERS FLUSH WITH GROUND LEVEL
  - GRP KIOSK
  - ABOVE GROUND VENT STACK
  - BELOW GROUND VENT STACK PIPEWORK
  - CABLE DUCTS
  - RISING MAIN
  - SEWER (MAIN FLOW THROUGH WORKS)
- EXISTING SERVICES LEGEND:**
- SEWER - COMBINED (WITH MANHOLE)
  - WATER MAIN - POTABLE
  - GLP - GAS MAIN - LOW PRESSURE
  - GMP - GAS MAIN - MEDIUM PRESSURE
  - LV - ELECTRIC - LOW VOLTAGE
  - EHV - ELECTRIC - EXTRA HIGH VOLTAGE
  - CATV - CABLE TV
- LOCATION OF EXISTING SERVICES SHOWN ARE FROM PIR DATA PROVIDED AND UNCONFIRMED

- GENERAL LEGEND:**
- DONALD RODGER ASSOCIATES LTD EXISTING TREES SURVEY AND TREE N°
  - CANOPY
  - ROOT EXTENTS

- REFERENCES:**
- DOA0024560-SN-DRA-04000101 PROPOSED ATTENUATION TANK LOCATION PLAN FOR PLANNING
  - DOA0024560-SN-DRA-04000103 PROPOSED ATTENUATION TANK SITE ELEVATIONS FOR PLANNING
  - DOA0024560-SN-DRA-04000104 PROPOSED ATTENUATION TANK PLAN FOR PLANNING
  - DOA0024560-SN-DRA-04000105 PROPOSED ATTENUATION TANK ELEVATIONS FOR PLANNING
  - DOA0024560-SN-DRA-04000106 PROPOSED MCC KIOSK GA FOR PLANNING

ID	Description	Drawn	Chk'd	App'd	Date
0D	For Information	SJF	GDH	GDH	01-Feb-22
0C	For Information	SJF	CMcN	GDH	18-Aug-21
0B	For Information	SJF	CMcN	CMcN	21-Jun-21
0A	For Information	SJF	CMcN	GDH	21-Jun-21

This drawing is the property of Scottish Water and must not be copied or used for any purpose other than that for which it is supplied without the written consent of Scottish Water.

SCOTTISH WATER  
CASTLE HOUSE  
6 CASTLE HOUSE  
CARNegie CAMPUS  
DUNFERMLINE  
FIFE KY11 8GG  
TEL: 01383 848200  
FAX: 01383 848371

CALEDONIA WATER ALLIANCE  
4 FLOOR, BUCHANAN TOWER  
BUCHANAN BUSINESS PARK  
CUMBERNAULD ROAD, STEPPS  
GLASGOW G33 6HZ  
TEL: 0141 212 6610

Originated By	Drawn By	Checked By	Approved By
SJF	SJF	CMcN	GDH


Date	Date	Date	Date
02-Jun-21	18-Jun-21	21-Jun-21	21-Jun-21

Scale	Status
1:200	FOR INFORMATION

**Project Title**  
MARCHMONT ROAD  
WARRENDER PARK ROAD EDINBURGH

**Drawing Title**  
PROPOSED ATTENUATION TANK  
SITE LAYOUT  
FOR PLANNING

ELLIPSE EQUIPMENT No. AAAAAAAAAA  
ELLIPSE PLANT No. XXXXXXXXXX | AUTOCODE No. 503594  
Drawing No. DOA0024560-SN-DRA-04000102-0D

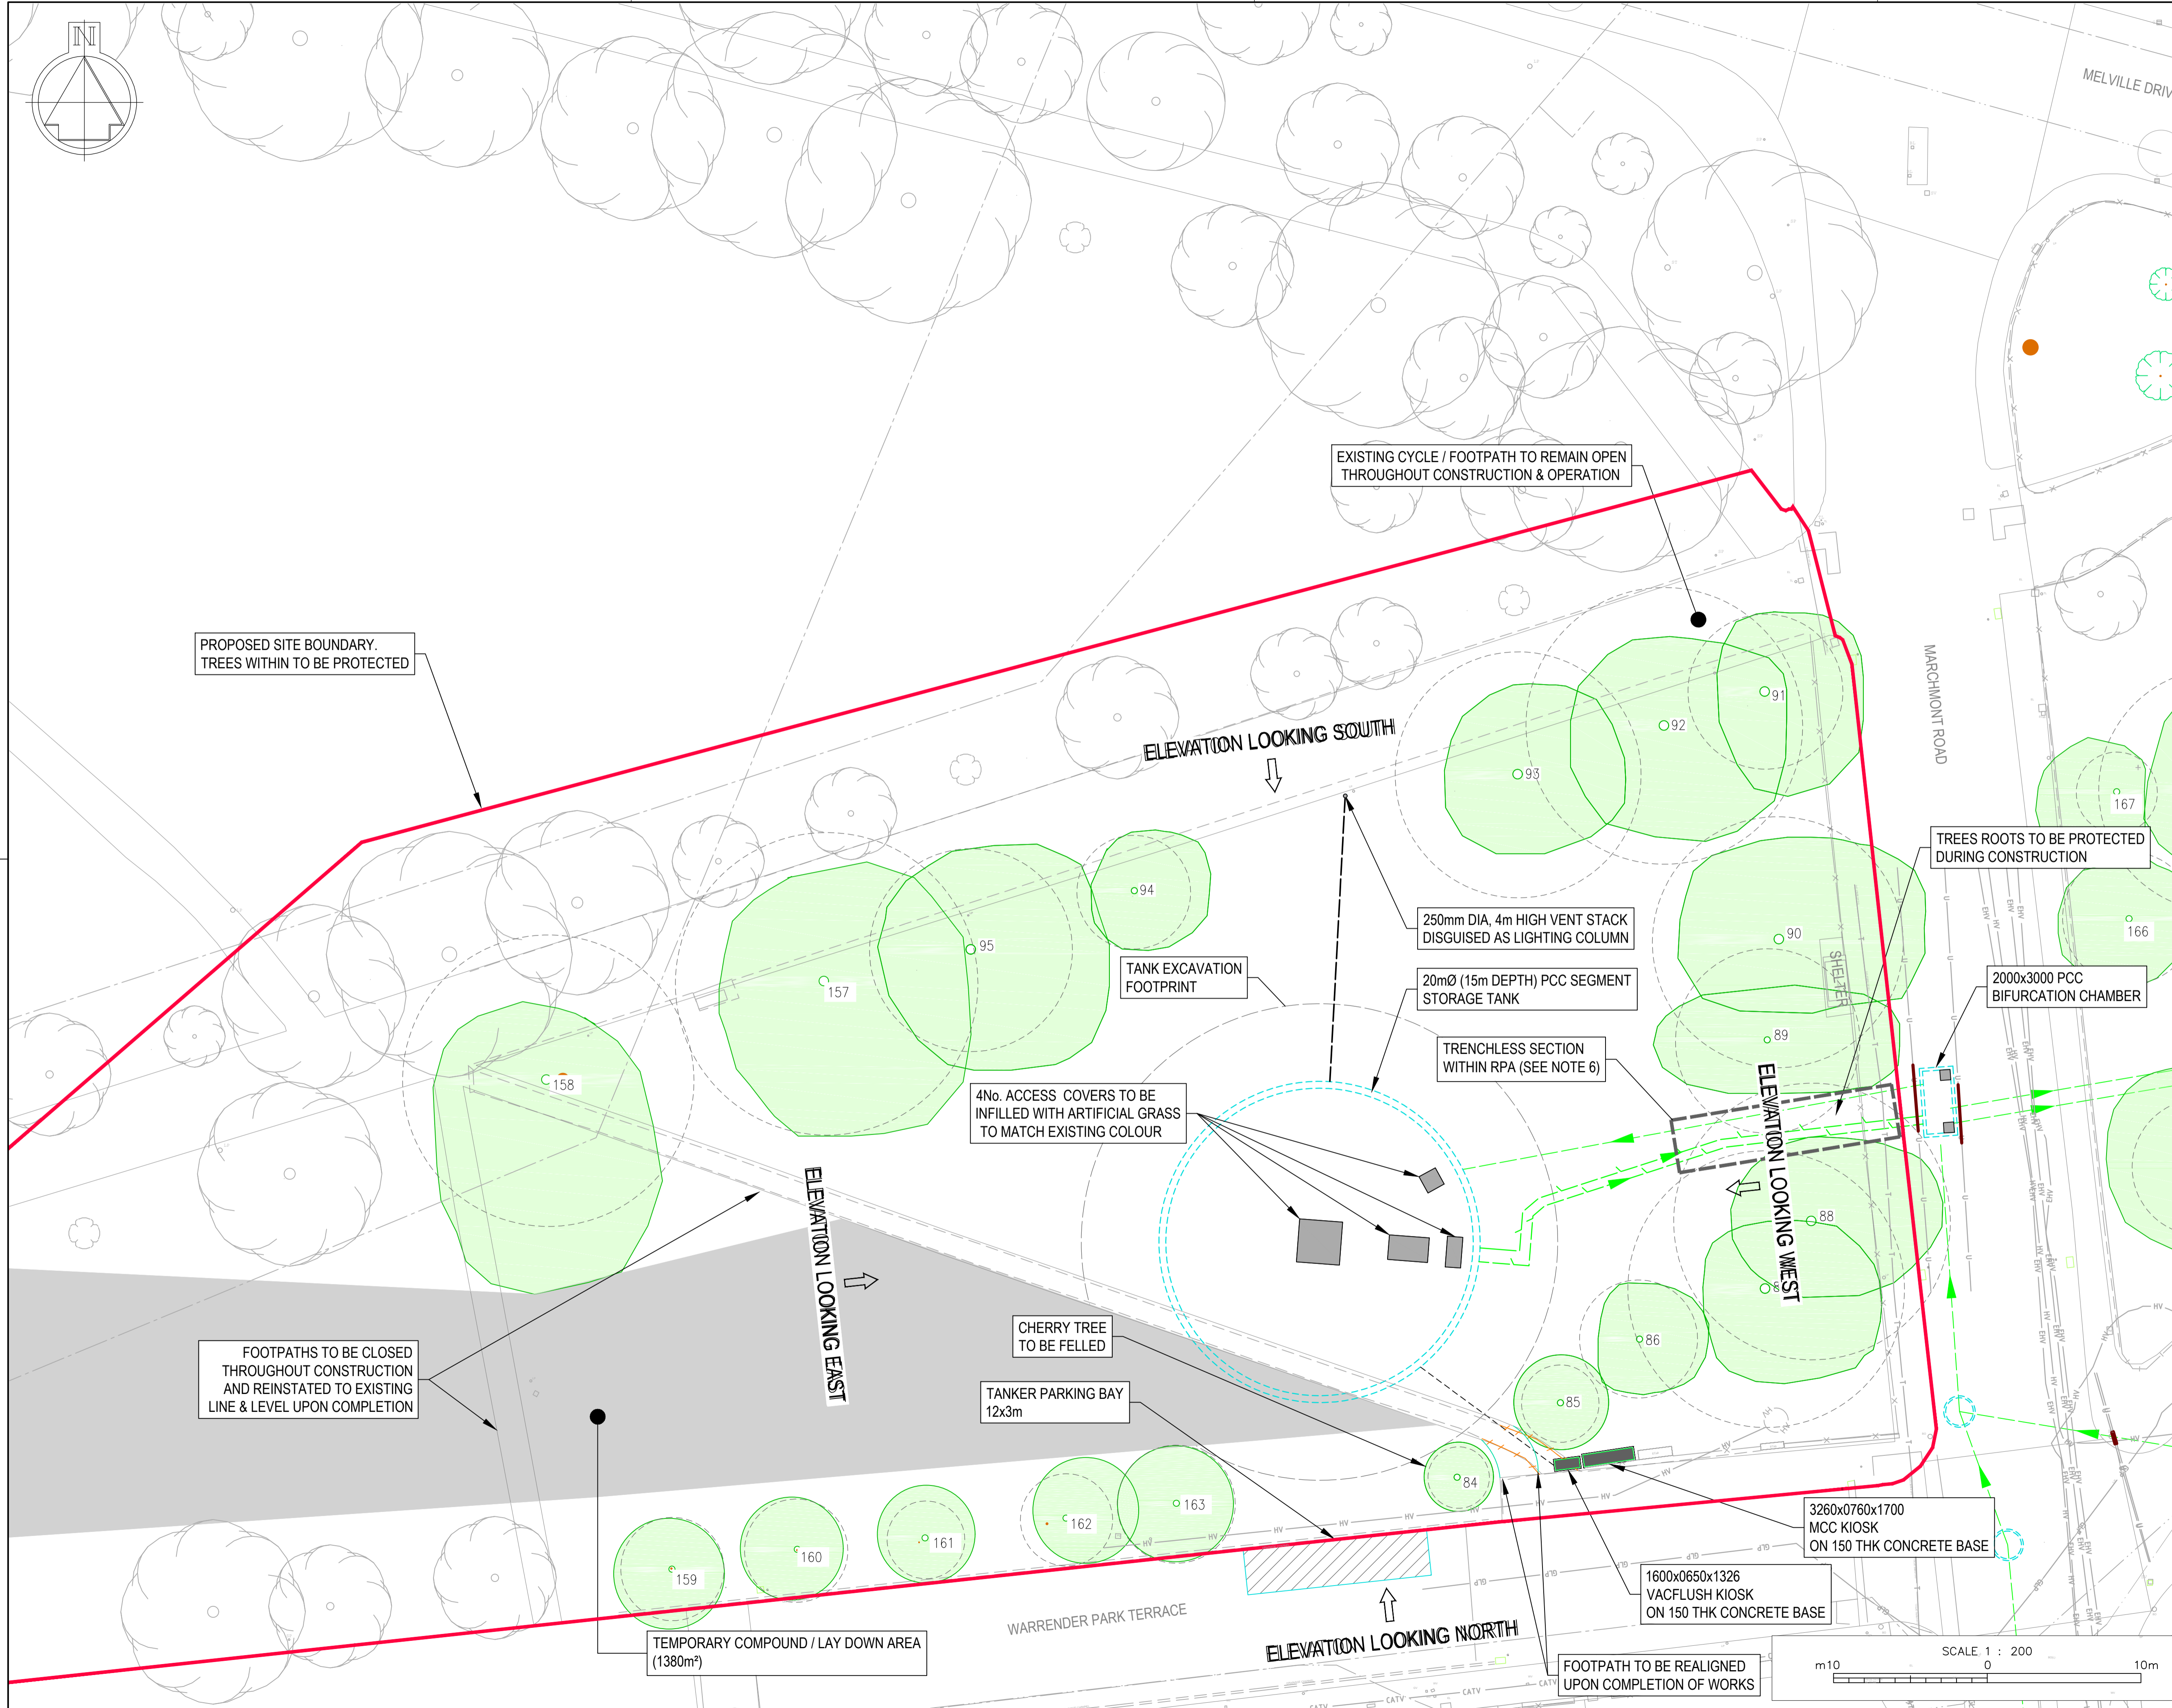

- Notes:
- ALL DIMENSIONS IN MILLIMETRES AND ALL LEVELS IN METRES UNLESS SHOWN OTHERWISE.
  - ALL DIMENSIONS AND LEVELS TO BE CHECKED ON SITE AND ANY DISCREPANCIES IDENTIFIED SHOULD BE REPORTED TO THE DESIGN ENGINEER PRIOR TO COMMENCEMENT OF WORK.
  - ALL LEVELS IN METRES (m) ABOVE ORDNANCE DATUM (AOD).

- GENERAL LEGEND:
- EXISTING GROUND PROFILE (EGL)
  - FINISHED GROUND PROFILE (FGL)
  - AREA OF FILL FROM EGL UP TO FGL
  - AREA OF CUT FROM EGL DOWN TO FGL
  - AREA OF NEW GRASSCRETE ACCESS ROAD

- REFERENCES:
- DOA0024560-SN-DRA-04000101
  - PROPOSED ATTENUATION TANK LOCATION PLAN FOR PLANNING
  - DOA0024560-SN-DRA-04000102
  - PROPOSED ATTENUATION TANK SITE LAYOUT FOR PLANNING
  - DOA0024560-SN-DRA-04000104
  - PROPOSED ATTENUATION TANK PLAN FOR PLANNING
  - DOA0024560-SN-DRA-04000105
  - PROPOSED ATTENUATION TANK ELEVATIONS FOR PLANNING
  - DOA0024560-SN-DRA-04000106
  - PROPOSED MCC KIOSK GA FOR PLANNING

COLOUR/MATERIAL SCHEDULE			
ITEM	MATERIAL	BS4800 : 2011 COLOUR REF.	
MCC KIOSK	GRP	14 C 39 HOLLY GREEN / HOLLYBUSH (TO BE AGREED WITH COUNCIL)	
VACFLUSH KIOSK	GRP	14 C 39 HOLLY GREEN / HOLLYBUSH (TO BE AGREED WITH COUNCIL)	
VENT STACK	DI	RAL 7000 SQUIRREL GREY (TO BE AGREED WITH COUNCIL)	

ID	Description	Drawn	Chk'd	App'd	Date
0D	For Information	SJF	GDH	GDH	01-Feb-22
0C	For Information	SJF	CMcN	GDH	18-Aug-21
0A	For Information	SJF	CMcN	GDH	21-Jun-21
0A	For Information	SJF	CMcN	GDH	21-Jun-21

This drawing is the property of Scottish Water and must not be copied or used for any purpose other than that for which it is supplied without the written consent of Scottish Water.

**SCOTTISH WATER**  
CASTLE HOUSE  
6 CASTLE HOUSE  
CARNegie CAMPUS  
DUNFERMLINE  
FIFE KY11 8GG  
TEL: 01383 848200  
FAX: 01383 848371


CALEDONIA WATER ALLIANCE  
1<sup>st</sup> FLOOR, BUCHANAN TOWER  
BUCHANAN BUSINESS PARK  
CUMBERNAULD ROAD, STEPPS  
GLASGOW G33 6HZ  
TEL: 0141 212 6610

Originated By	Drawn By	Checked By	Approved By
SJF	SJF	CMcN	GDH
Date	Date	Date	Date
04-Jun-21	18-Jun-21	21-Jun-21	21-Jun-21
Scale	Status		
1:200	FOR INFORMATION		


Project Title  
**MARCHMONT ROAD  
WARRENDER PARK ROAD EDINBURGH**

Drawing Title  
**PROPOSED ATTENUATION TANK  
SITE ELEVATIONS  
FOR PLANNING**


ELLIPSE EQUIPMENT No. AAAAAAAAAA  
ELLIPSE PLANT No. XXXXXXXXXX | AUTOCODE No. 503594  
Drawing No.  
**DOA0024560-SN-DRA-04000103-0D**

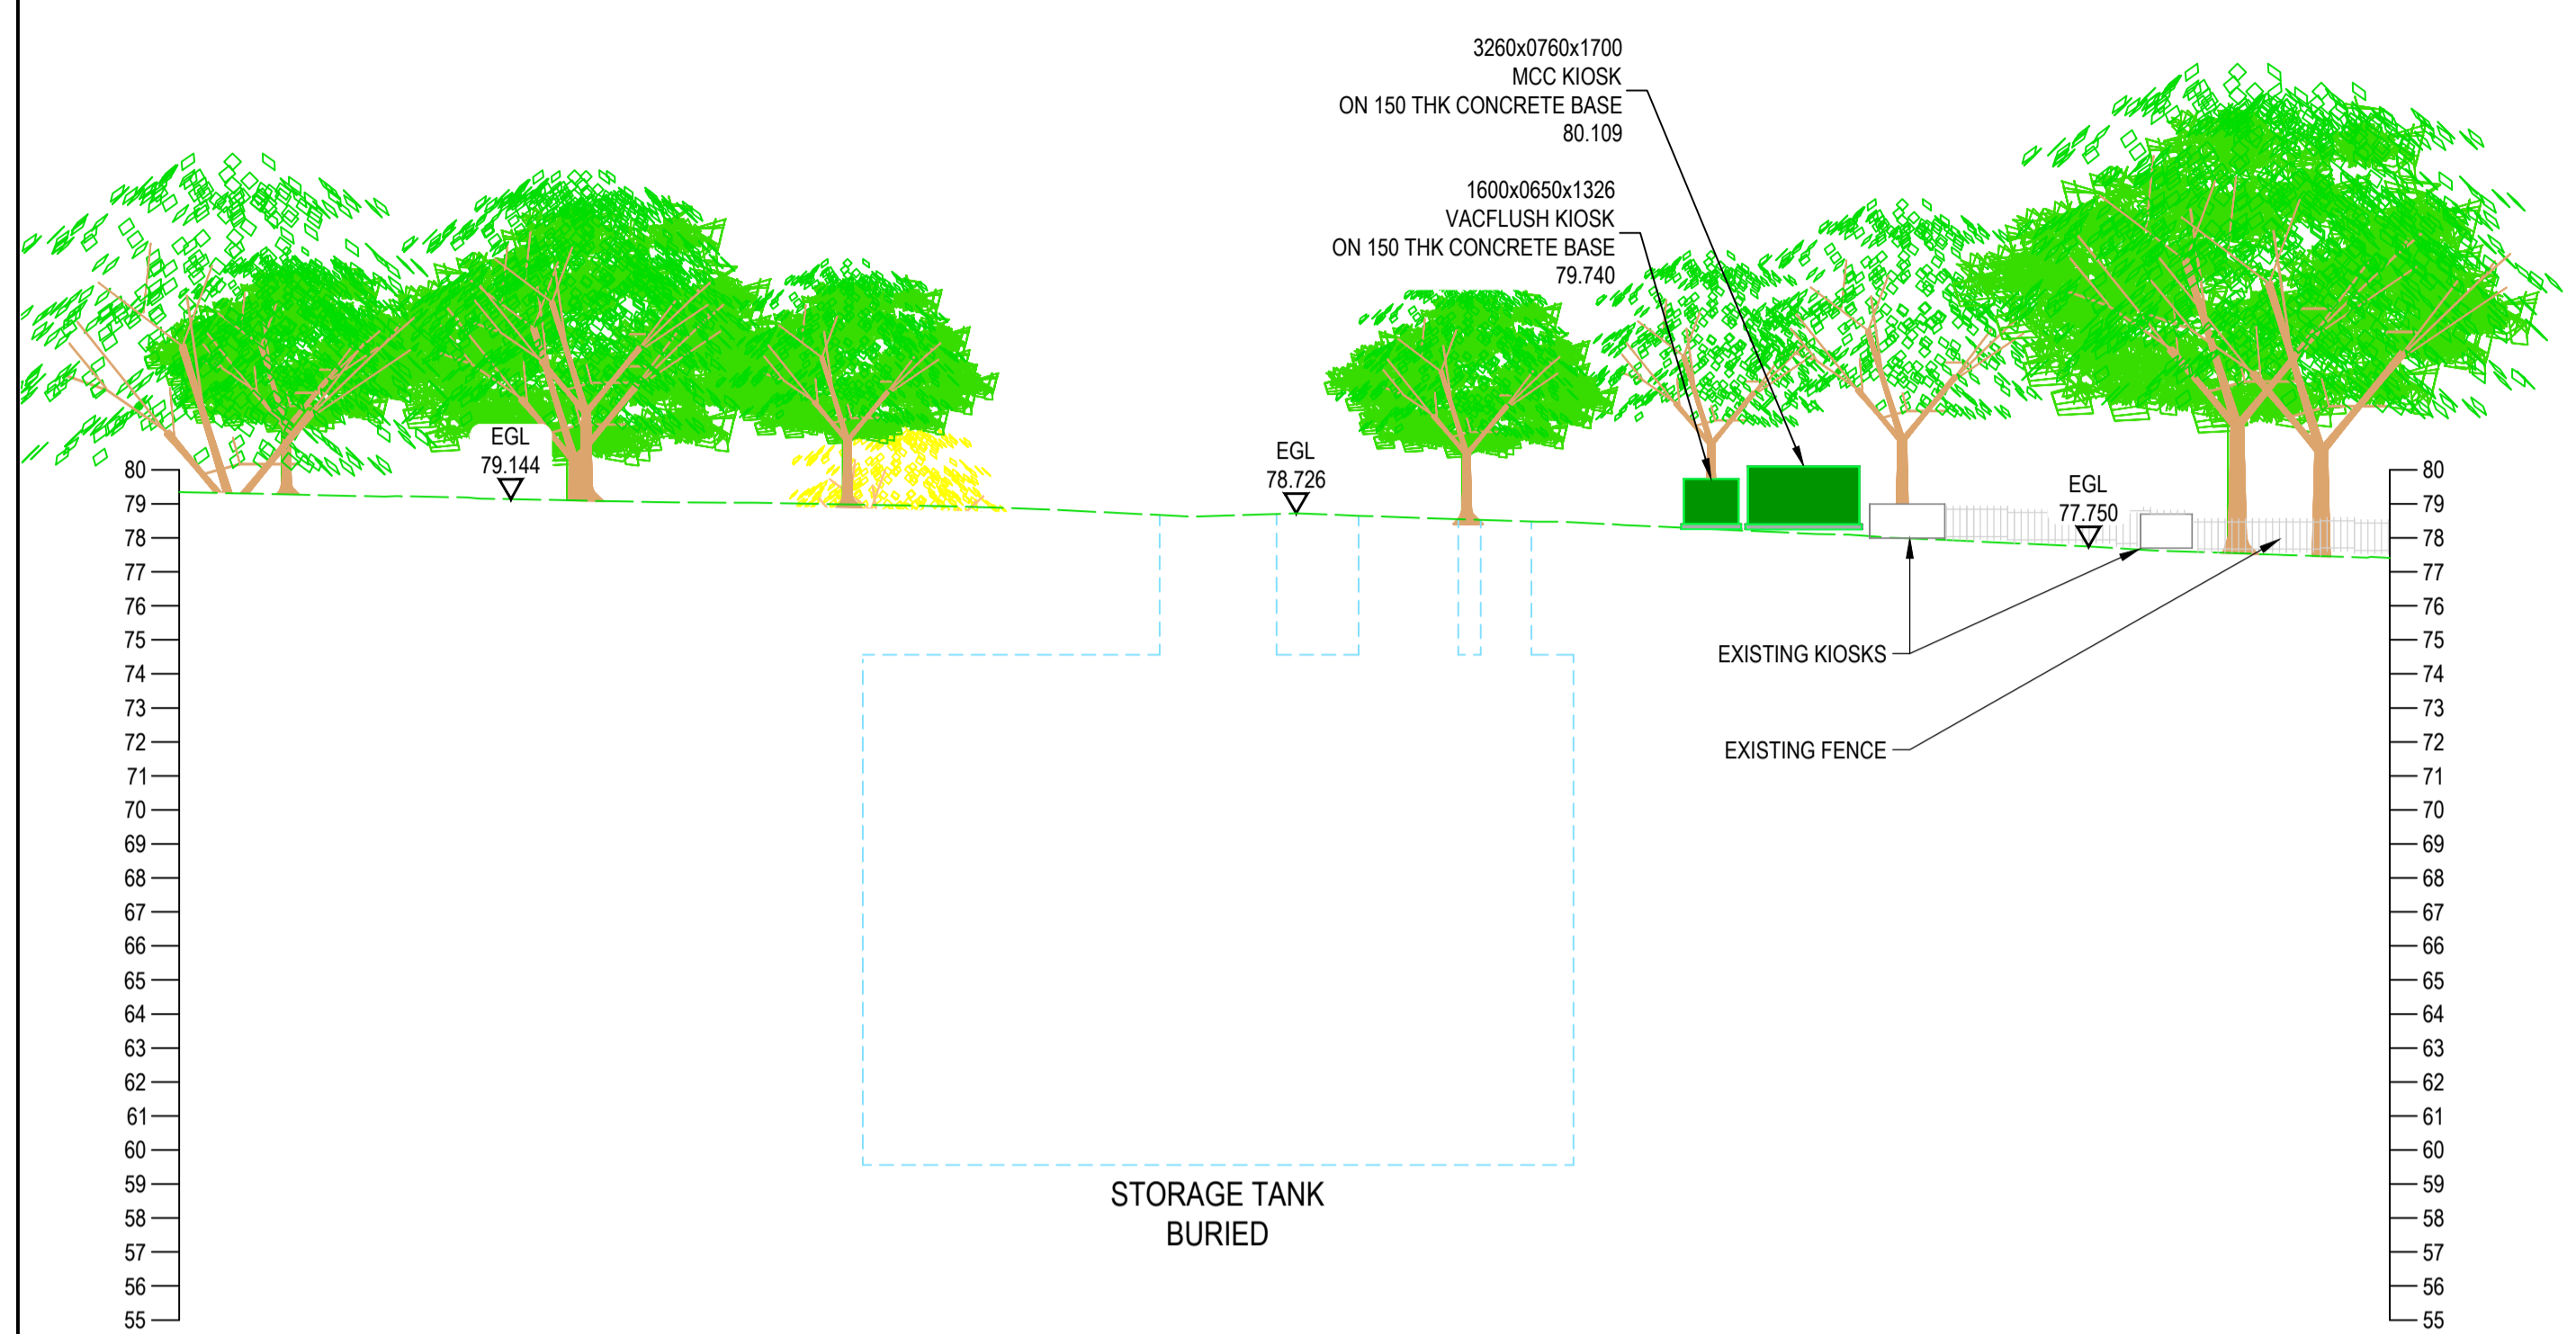


**ELEVATION LOOKING NORTH**

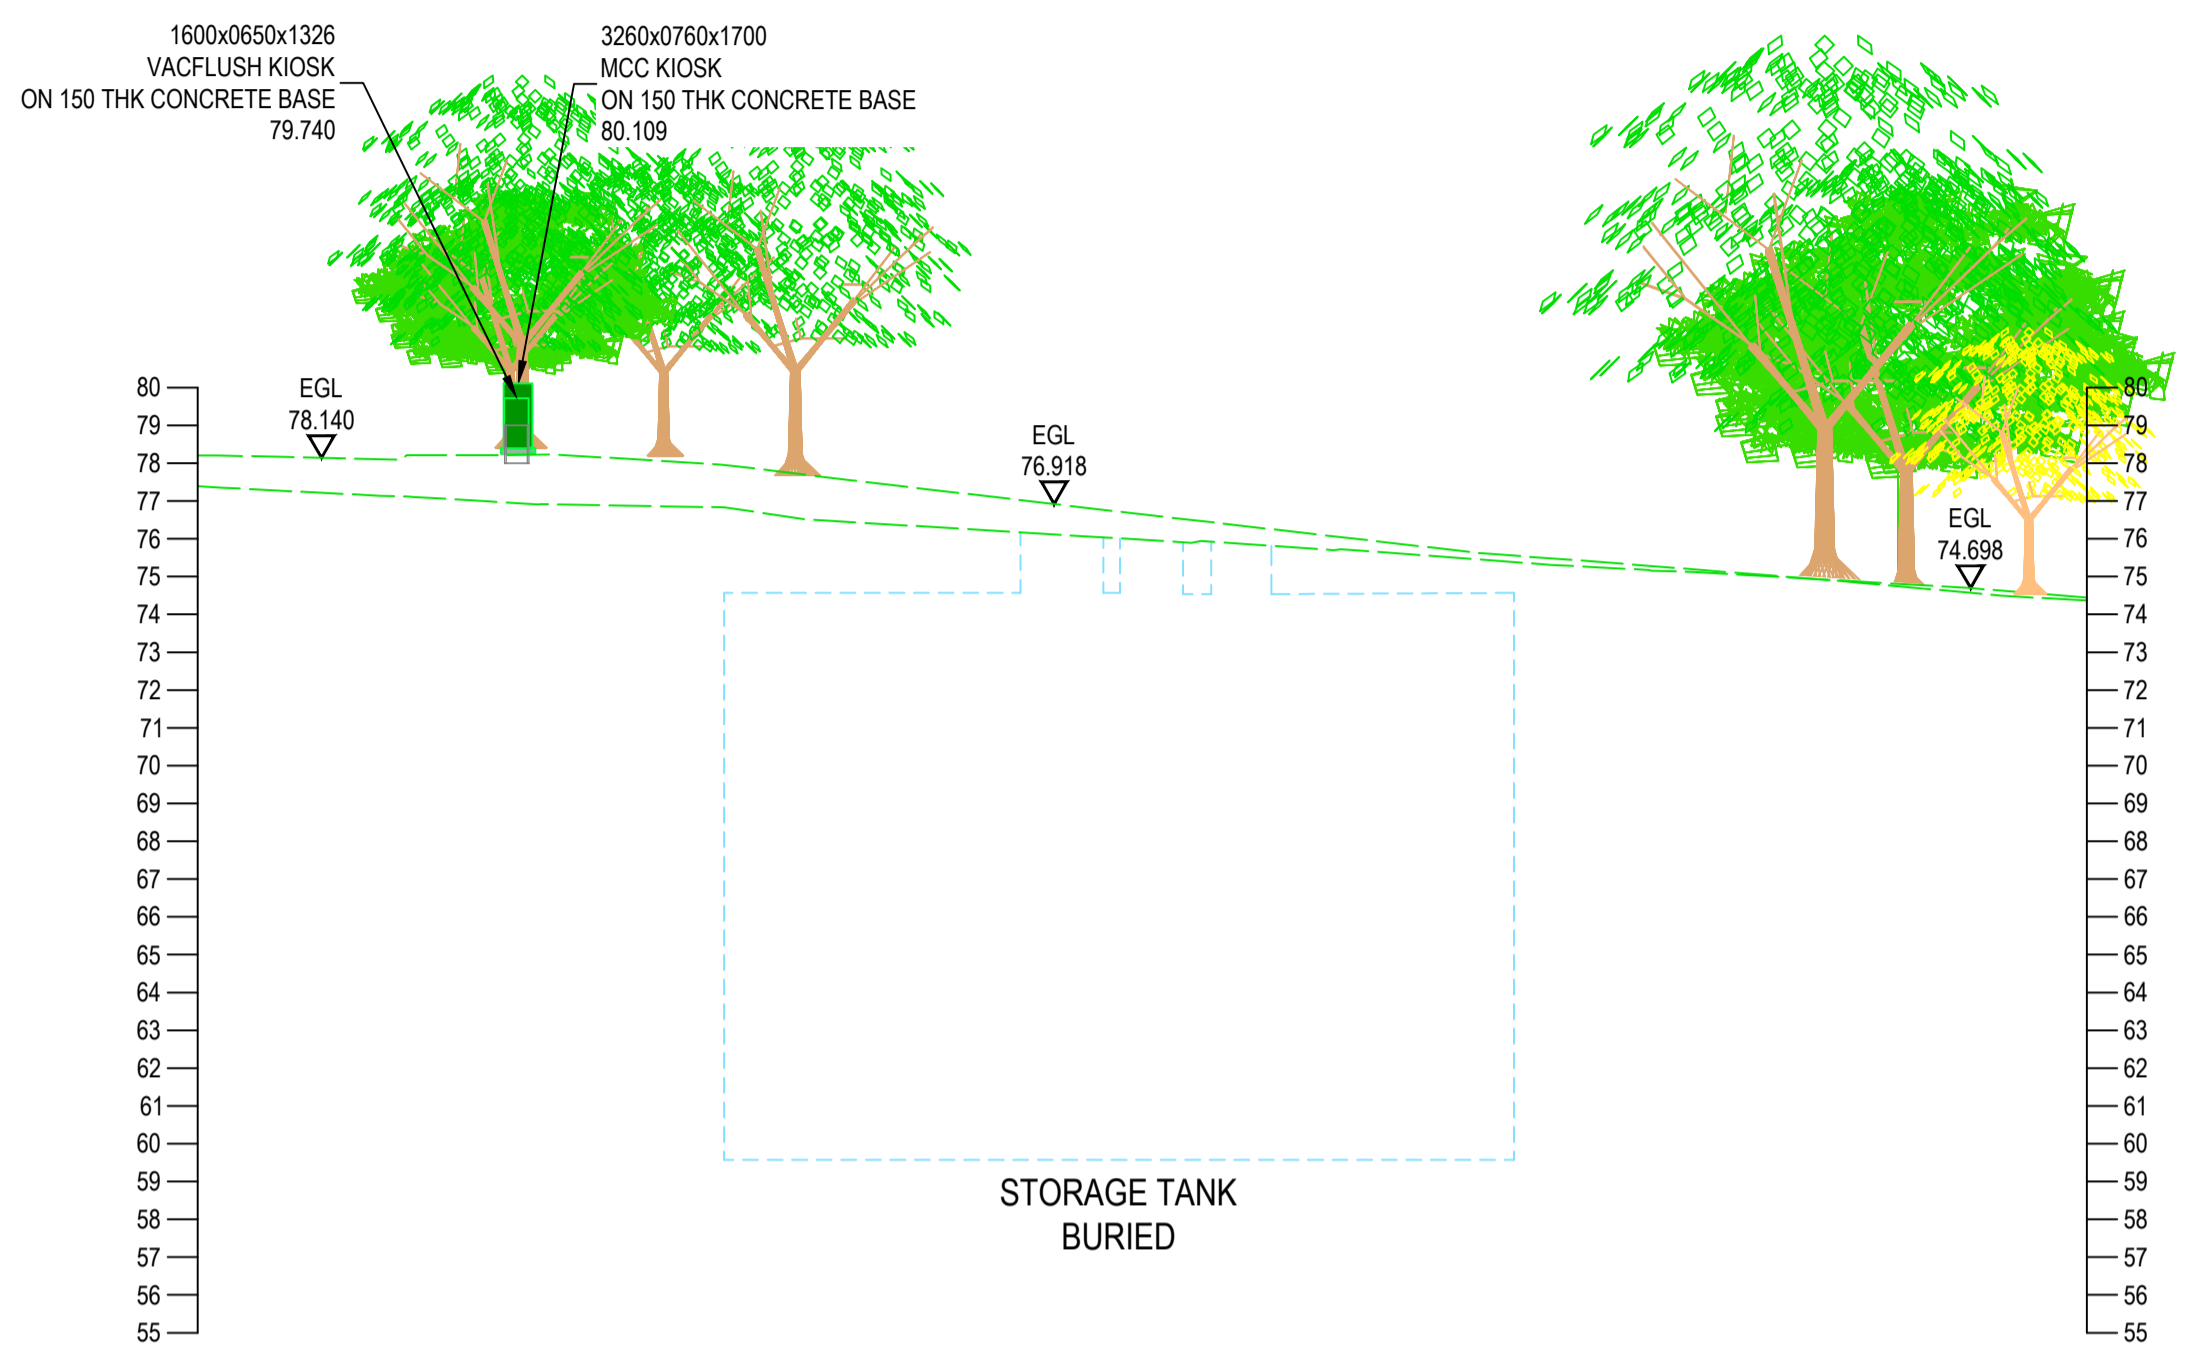


**ELEVATION LOOKING WEST**

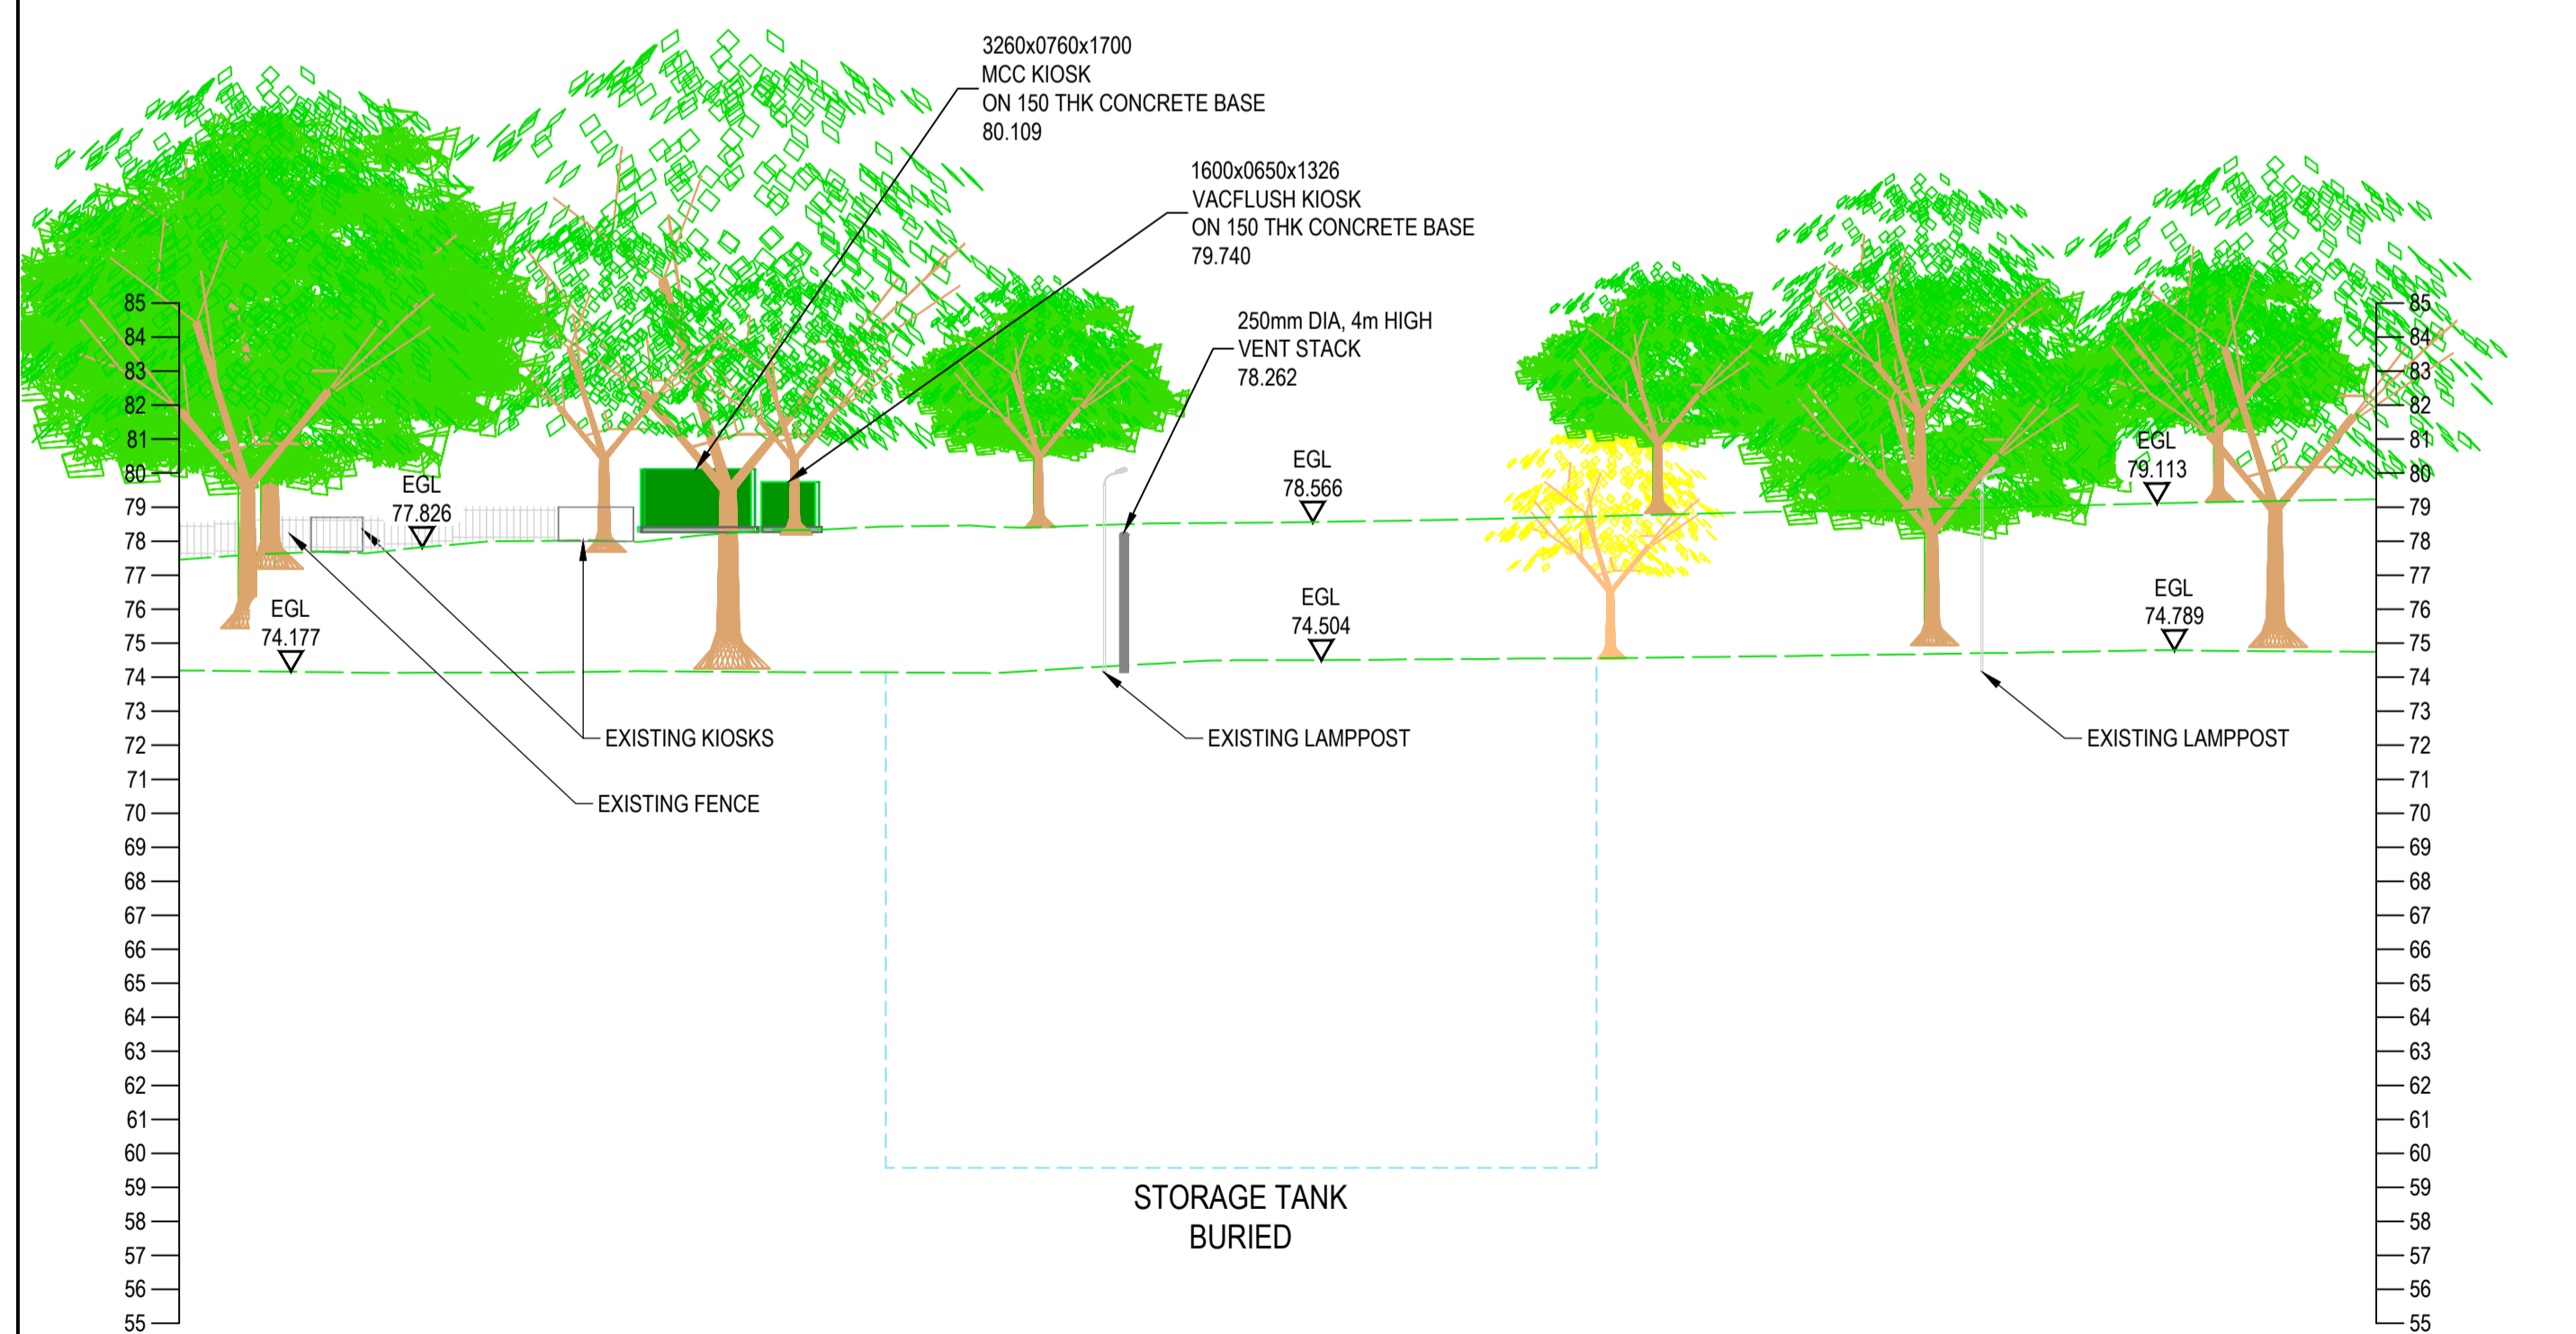


**ELEVATION LOOKING SOUTH**

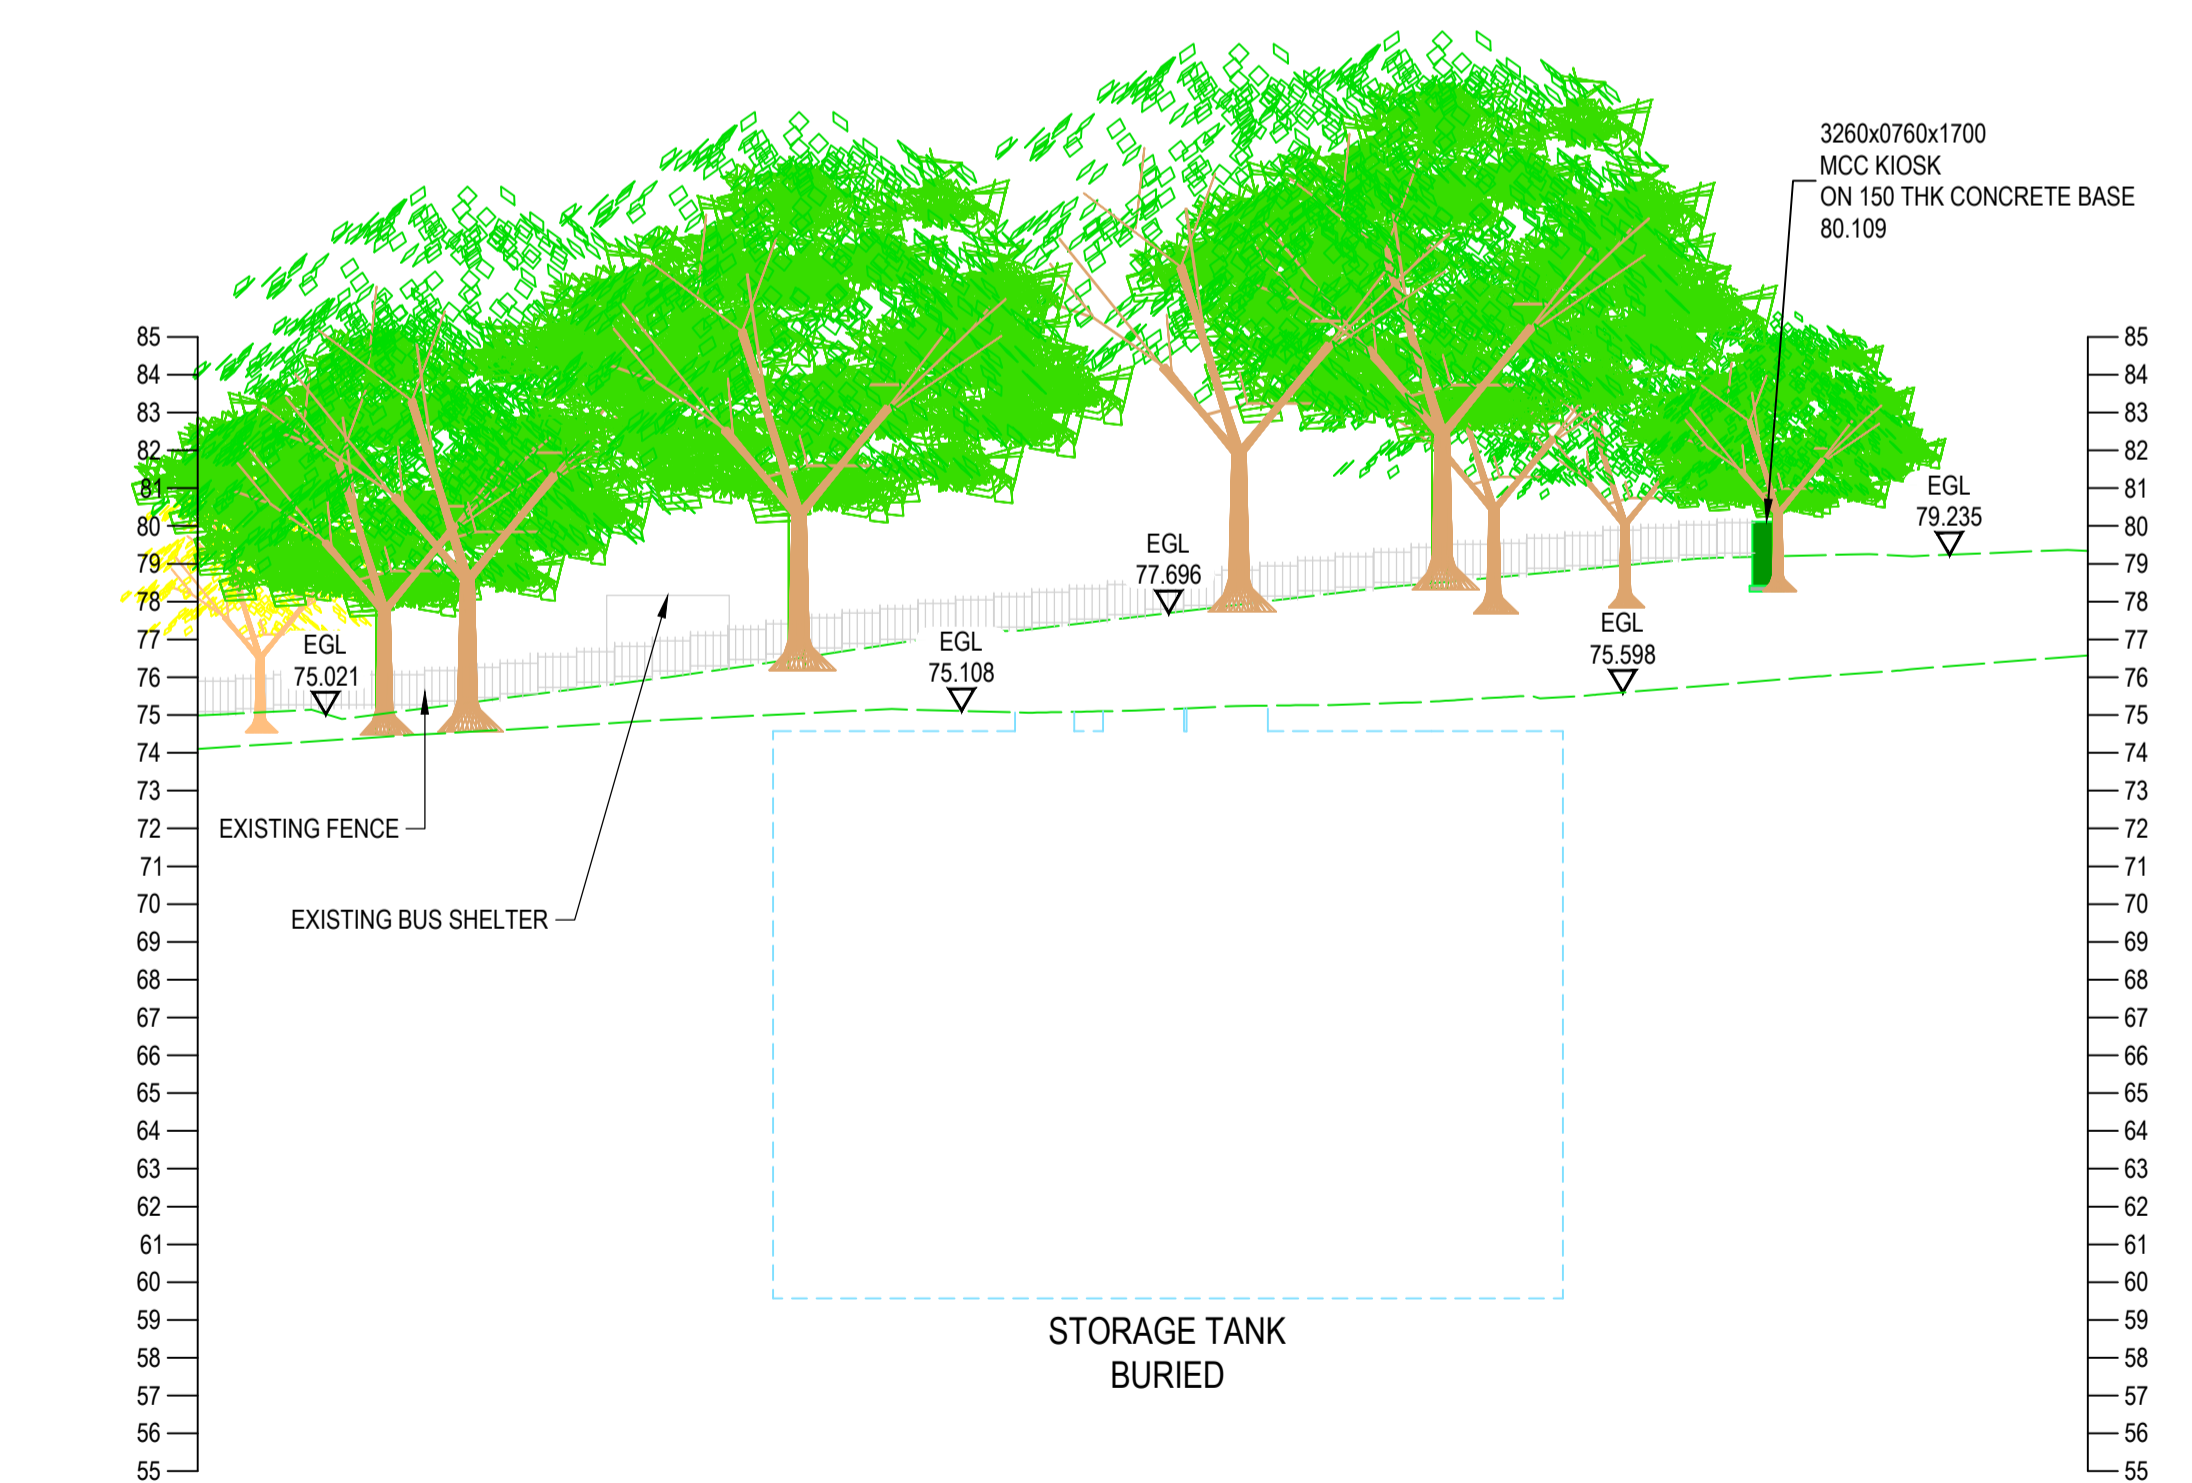


**ELEVATION LOOKING EAST**

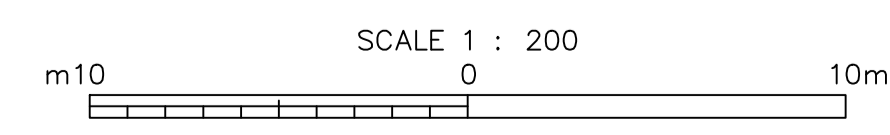


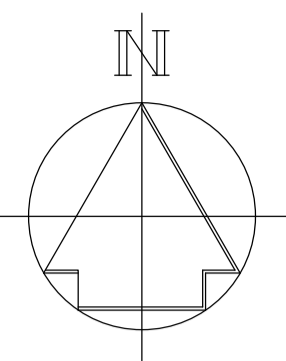

**Notes:**  
1. ALL DIMENSIONS IN MILLIMETRES AND LEVELS IN METRES AOD, UNLESS NOTED OTHERWISE.

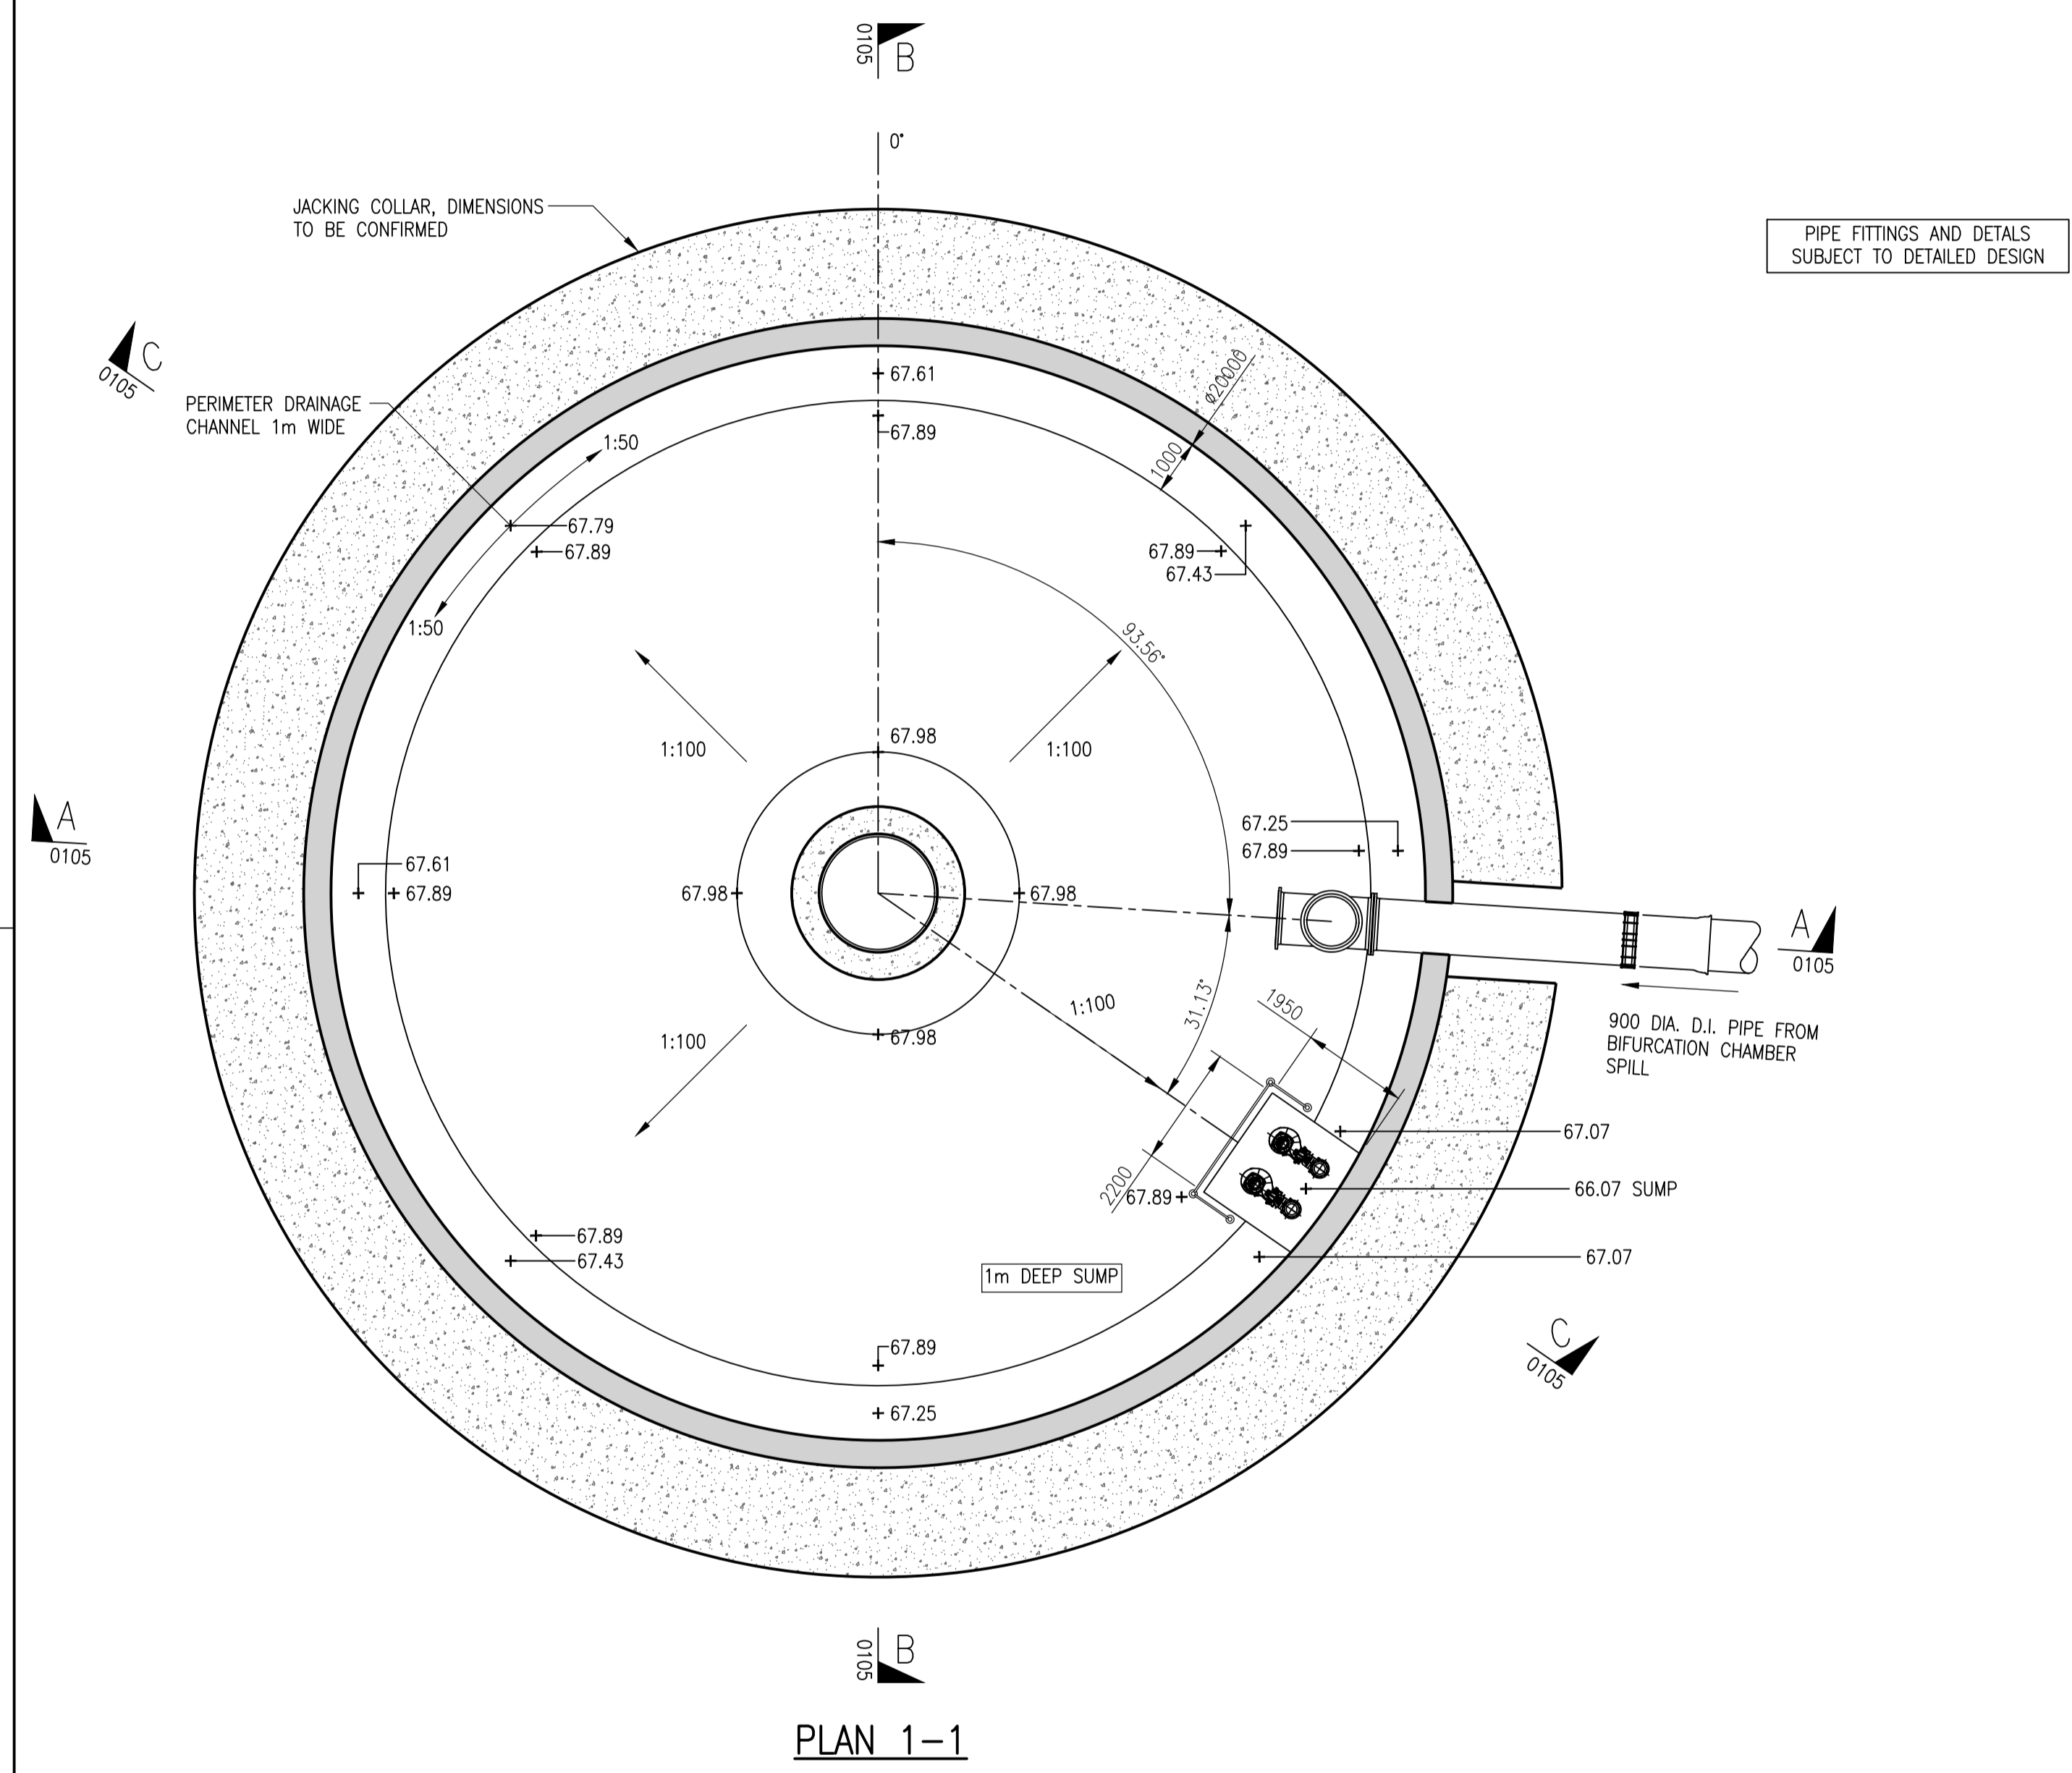

**PLAN 1-1**

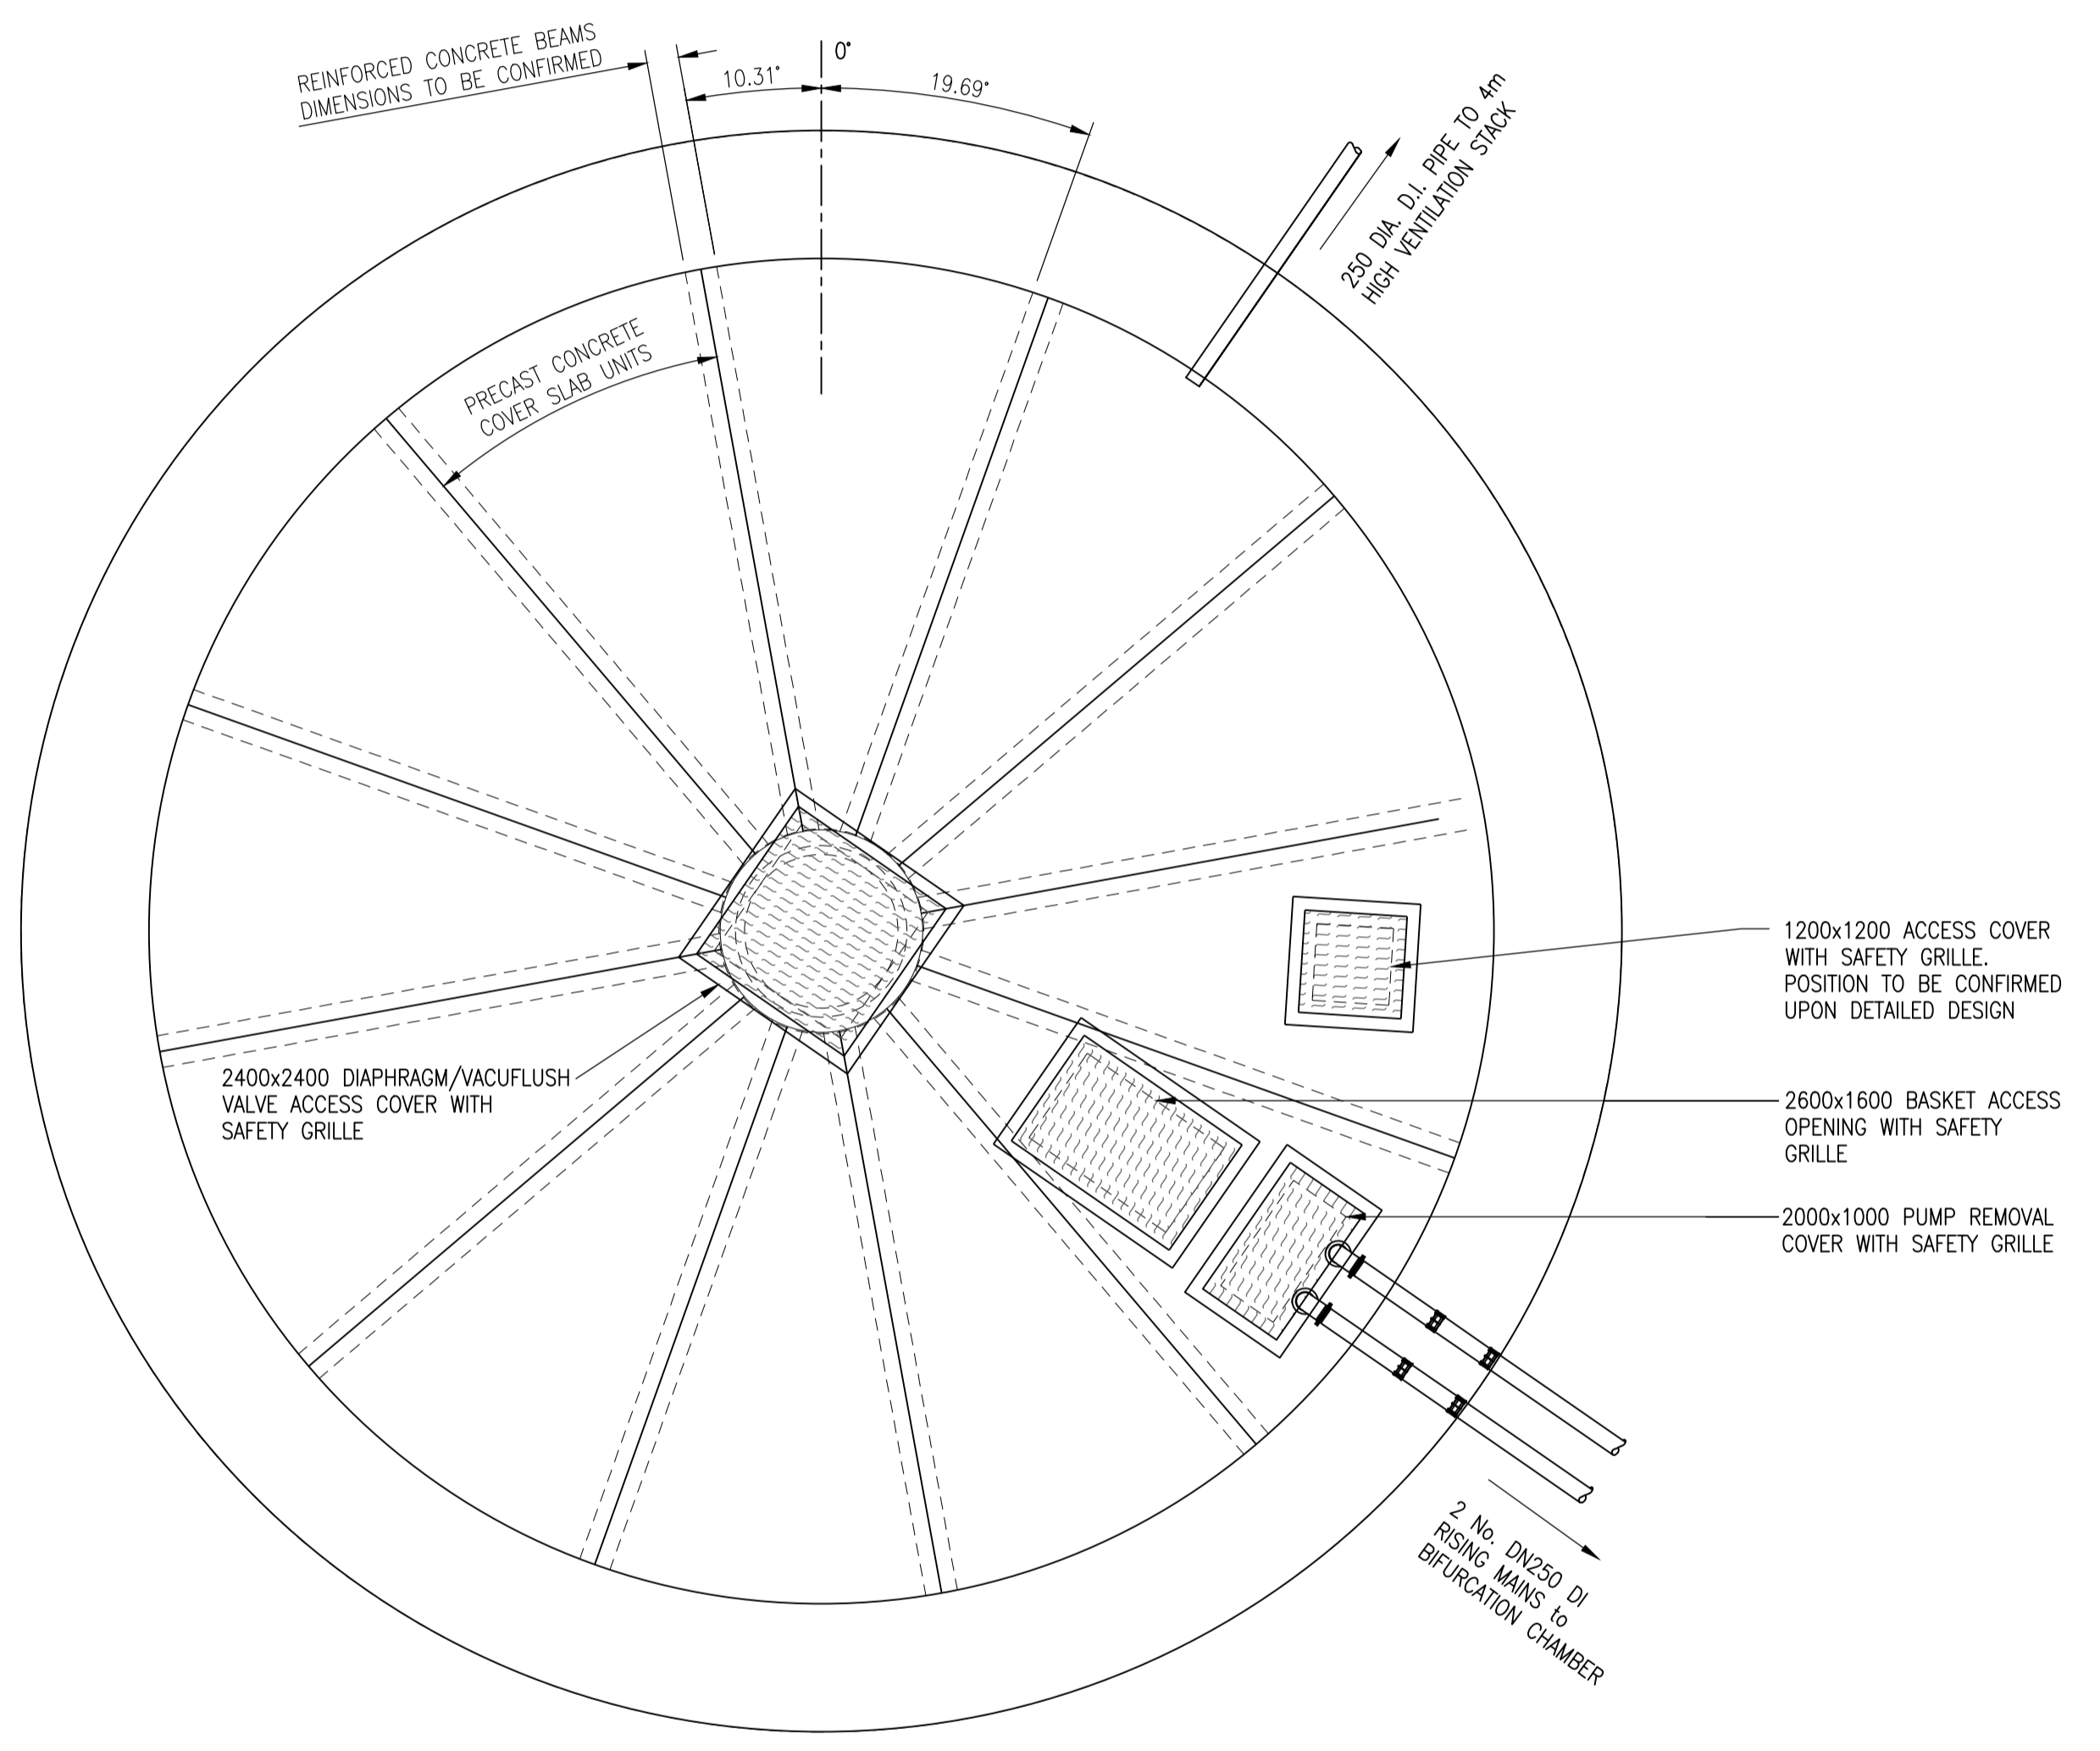

**PLAN 2-2**

PIPE FITTINGS AND DETAILS SUBJECT TO DETAILED DESIGN

- REFERENCES:**
- DOA0024560-SN-DRA-04000101 PROPOSED ATTENUATION TANK LOCATION PLAN FOR PLANNING
  - DOA0024560-SN-DRA-04000102 PROPOSED ATTENUATION TANK SITE LAYOUT FOR PLANNING
  - DOA0024560-SN-DRA-04000103 PROPOSED ATTENUATION TANK SITE ELEVATIONS FOR PLANNING
  - DOA0024560-SN-DRA-04000105 PROPOSED ATTENUATION TANK ELEVATIONS FOR PLANNING
  - DOA0024560-SN-DRA-04000106 PROPOSED MCC KIOSK GA FOR PLANNING

Rev	Description	Drawn	Chk'd	App'd	Date
0D	For Information	SJF	GDH	GDH	01-Feb-22
0C	For Information	SJF	CMcN	GDH	18-Aug-21
0B	For Information	SJF	CMcN	CMcN	21-Jun-21
0A	For Information	SJF	CMcN	GDH	21-Jun-21

This drawing is the property of Scottish Water and must not be copied or used for any purpose other than that for which it is supplied without the written consent of Scottish Water.

**SCOTTISH WATER**  
CASTLE HOUSE  
6 CASTLE HOUSE  
CARNEGIE CAMPUS  
DUNFERMLINE  
FIFE KY11 8GG  
TEL: 01383 848200  
FAX: 01383 848371

CALEDONIA WATER ALLIANCE  
11 FLOOR, BUCHANAN TOWER  
BUCHANAN BUSINESS PARK  
CUMBERNAULD ROAD, STEPPS  
GLASGOW G33 6HZ  
TEL: 0141 212 6610

Originated By	Drawn By	Checked By	Approved By
SJF	SJF	CMcN	GDH
Date	Date	Date	Date
18-Jun-21	18-Jun-21	21-Jun-21	21-Jun-21

Scale: 1:100  
Status: FOR INFORMATION

Project Title  
**MARCHMONT ROAD  
WARRENDER PARK ROAD EDINBURGH**

Drawing Title  
**PROPOSED  
ATTENUATION TANK PLANS  
FOR PLANNING**

ELLIPSE EQUIPMENT No. AAAAAAAAAA  
ELLIPSE PLANT No. XXXXXXXXXX | AUTOCODE No. 503594

Drawing No.  
**DOA0024560-SN-DRA-04000104-0D**

**SCOTTISH WATER**  
HEALTH AND SAFETY INFORMATION


IN ADDITION TO THE HAZARDS NORMALLY ASSOCIATED WITH THE TYPES OF WORK DETAILED ON THIS DRAWING, PLEASE NOTE THE FOLLOWING:

CONSTRUCTION PHASE	
(S1) Existing Services - Crossing of MP Gas pipe and HV electric cable required. Risk to construction team.	All scheduled trial holes to be complete before construction begins to confirm all locations, diameters and depths. Combined services drawing to be updated to reflect site information. Diversions and crossings to be agreed with utility providers.

SW OPs ACCESS - HORI, VERT, PEDESTRIAN, VEHICLE/PLANT	METHOD OF ACCESS:
Manholes	Scottish Water safe systems of work
All new manholes	SW safe systems of work should be in place. Standard access arrangements

SW OPs HANDLING/LIFTING STRATEGY	METHOD OF HANDLING:
ITEMS REQUIRING HANDLING:	Manhole lift, Scottish water procedure. SSOW.
Covers	

IT IS ASSUMED THAT ALL WORKS WILL BE CARRIED OUT BY A COMPETENT PERSON WORKING, WHERE APPROPRIATE, TO AN APPROVED SAFE SYSTEM OF WORK

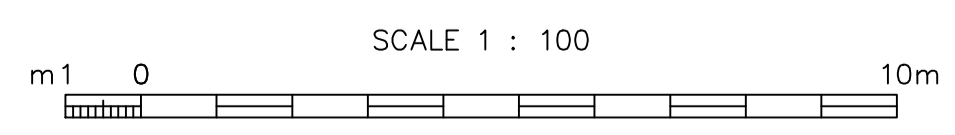

Notes:  
1. ALL DIMENSIONS IN METRES AND ALL LEVELS IN METRES AOD, UNLESS NOTED OTHERWISE.

- REFERENCES:  
 DOA0024560-SN-DRA-04000101  
 PROPOSED ATTENUATION TANK LOCATION PLAN FOR PLANNING  
 DOA0024560-SN-DRA-04000102  
 PROPOSED ATTENUATION TANK SITE LAYOUT FOR PLANNING  
 DOA0024560-SN-DRA-04000103  
 PROPOSED ATTENUATION TANK SITE ELEVATIONS FOR PLANNING  
 DOA0024560-SN-DRA-04000104  
 PROPOSED ATTENUATION TANK PLANS FOR PLANNING  
 DOA0024560-SN-DRA-04000105  
 PROPOSED MCC KIOSK GA FOR PLANNING

Rev	Description	Drawn	Chk'd	App'd	Date
0D	For Information	SJF	GDH	GDH	01-Feb-22
0C	For Information	SJF	CMcN	GDH	18-Aug-21
0B	For Information	SJF	CMcN	CMcN	21-Jun-21
0A	For Information	SJF	CMcN	GDH	21-Jun-21

This drawing is the property of Scottish Water and must not be copied or used for any purpose other than that for which it is supplied without the written consent of Scottish Water.

SCOTTISH WATER  
 CASTLE HOUSE  
 6 CASTLE HOUSE  
 CARNEGIE CAMPUS  
 DUNFERMLINE  
 FIFE KY11 8GG  
 TEL: 01383 848200  
 FAX: 01383 848371

CALEDONIA WATER ALLIANCE  
 1<sup>st</sup> FLOOR, BUCHANAN TOWER  
 BUCHANAN BUSINESS PARK  
 CUMBERNAULD ROAD, STEPPS  
 GLASGOW G33 6HZ  
 TEL: 0141 212 6610


Originated By	Drawn By	Checked By	Approved By
SJF	SJF	CMcN	GDH
Date	Date	Date	Date
18-Jun-21	18-Jun-21	21-Jun-21	21-Jun-21
Scale	Status		
1:100	FOR INFORMATION		

Project Title  
**MARCHMONT ROAD  
 WARRENDER PARK ROAD EDINBURGH**


Drawing Title  
**PROPOSED  
 ATTENUATION TANK SECTIONS  
 FOR PLANNING**

ELLIPSE EQUIPMENT No. AAAAAAAAAA  
 ELLIPSE PLANT No. XXXXXXXXXX AUTOCODE No. 503594


Drawing No.  
**DOA0024560-SN-DRA-04000105-0D**

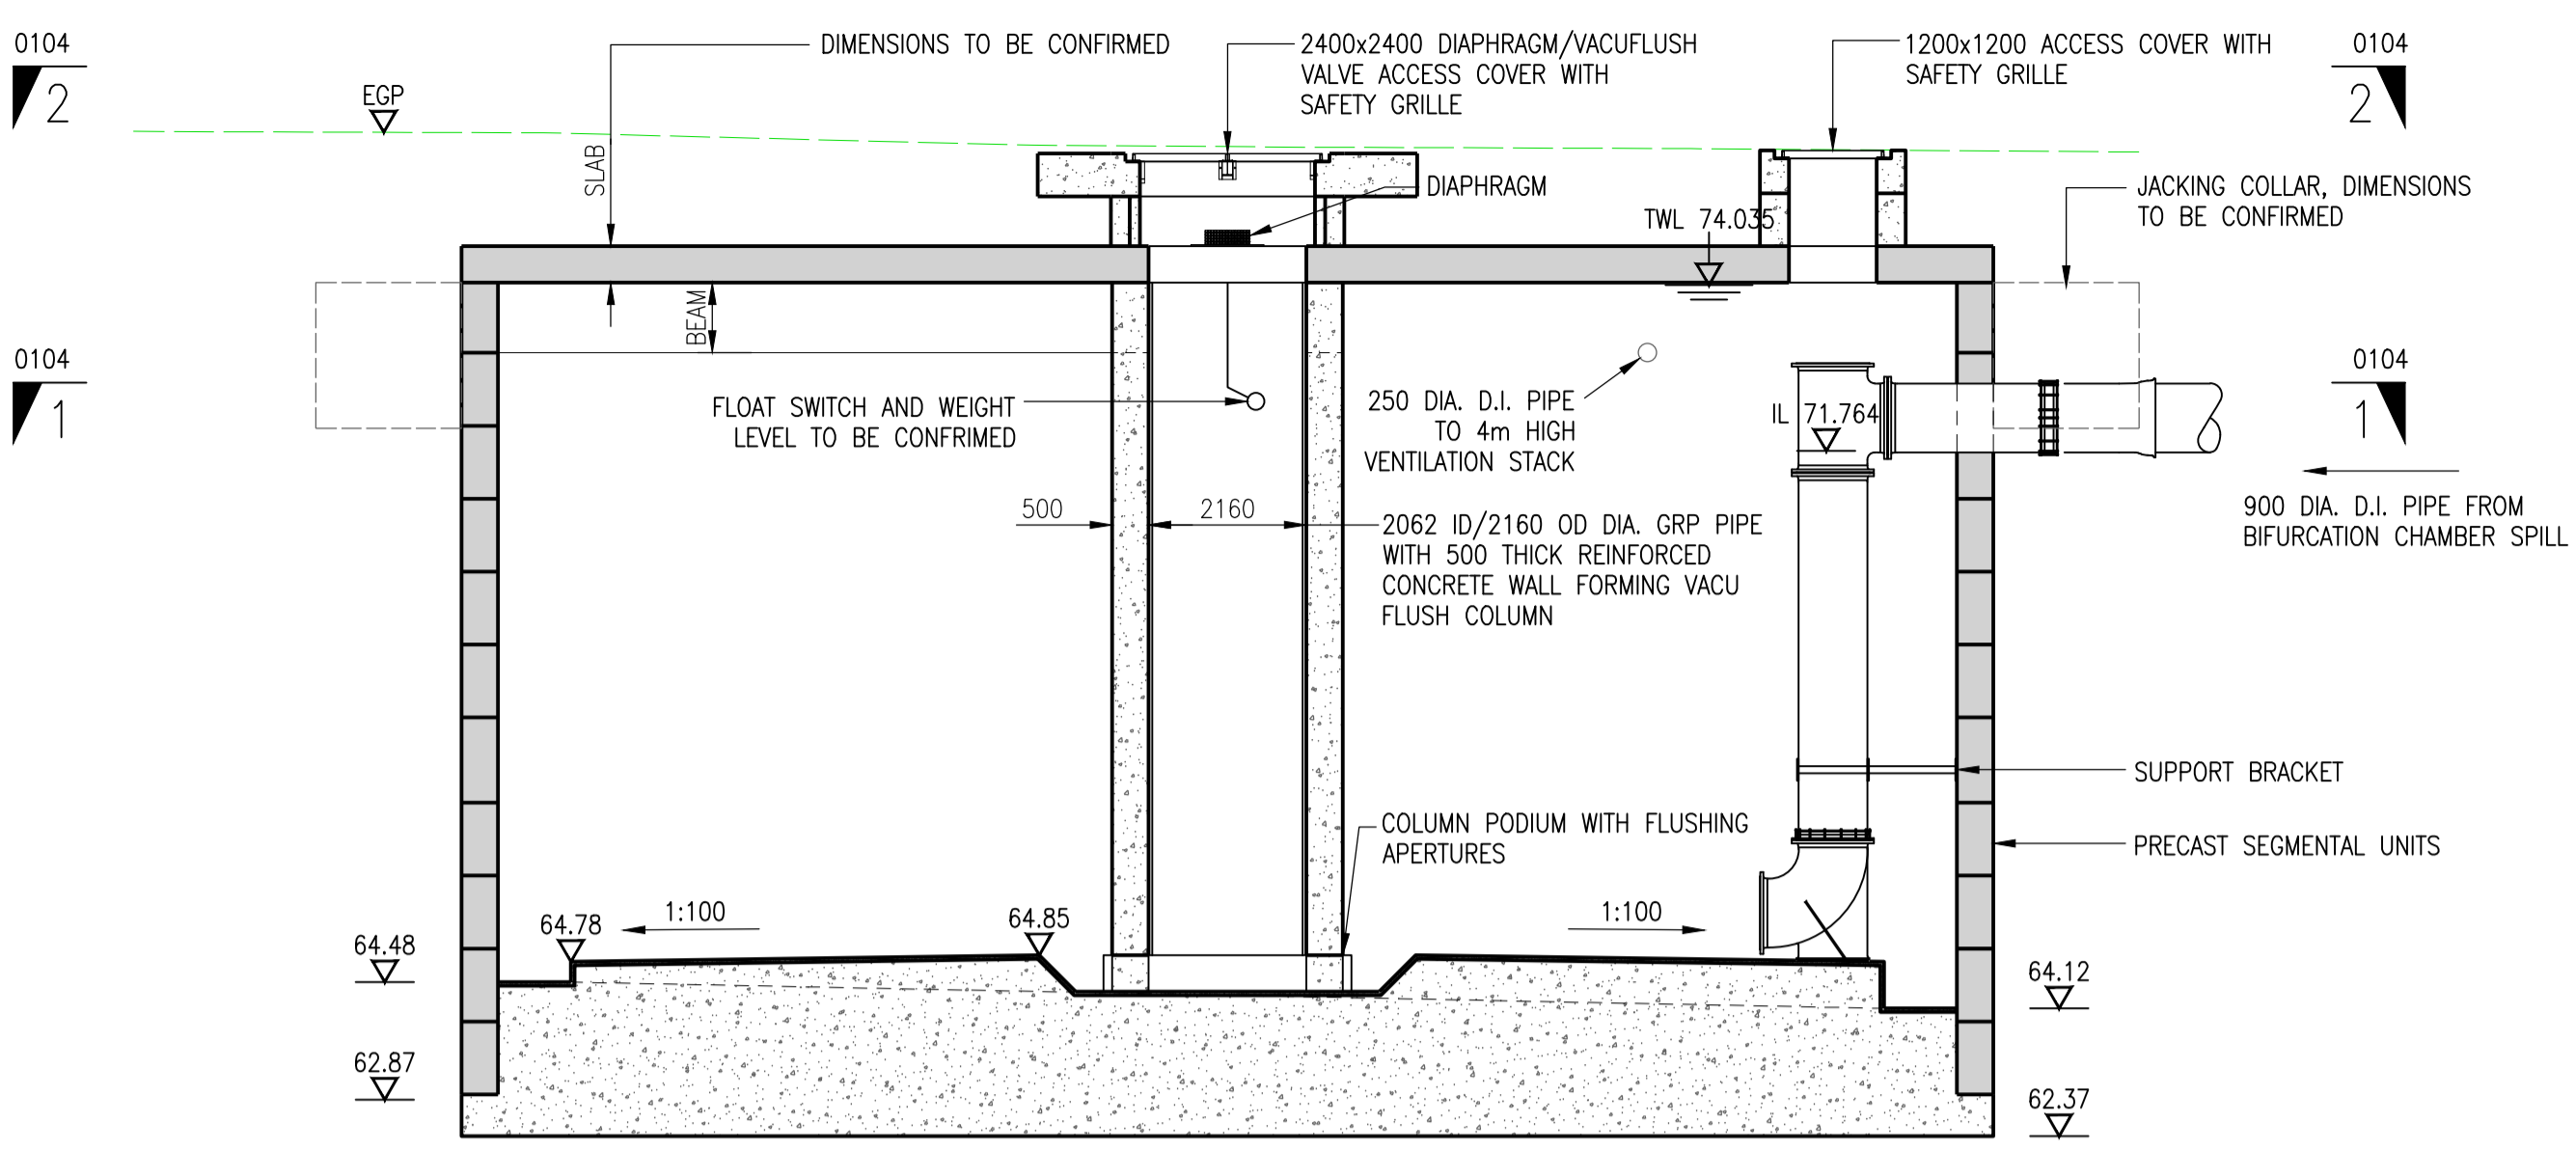

SECTION A-A

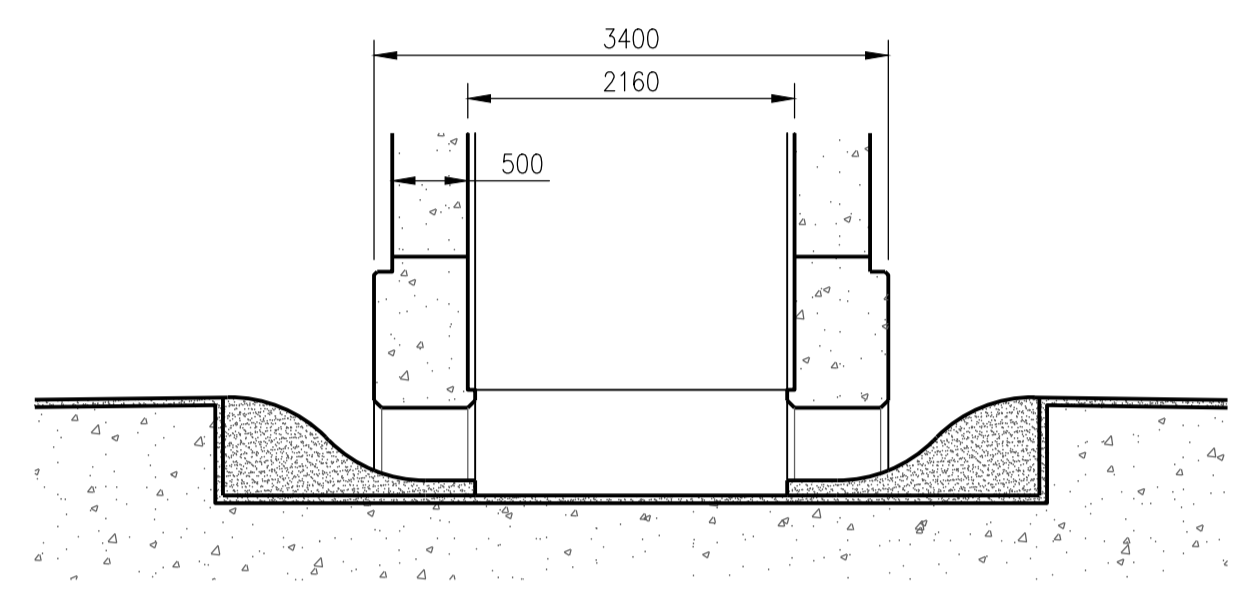


SECTIONAL ELEVATION

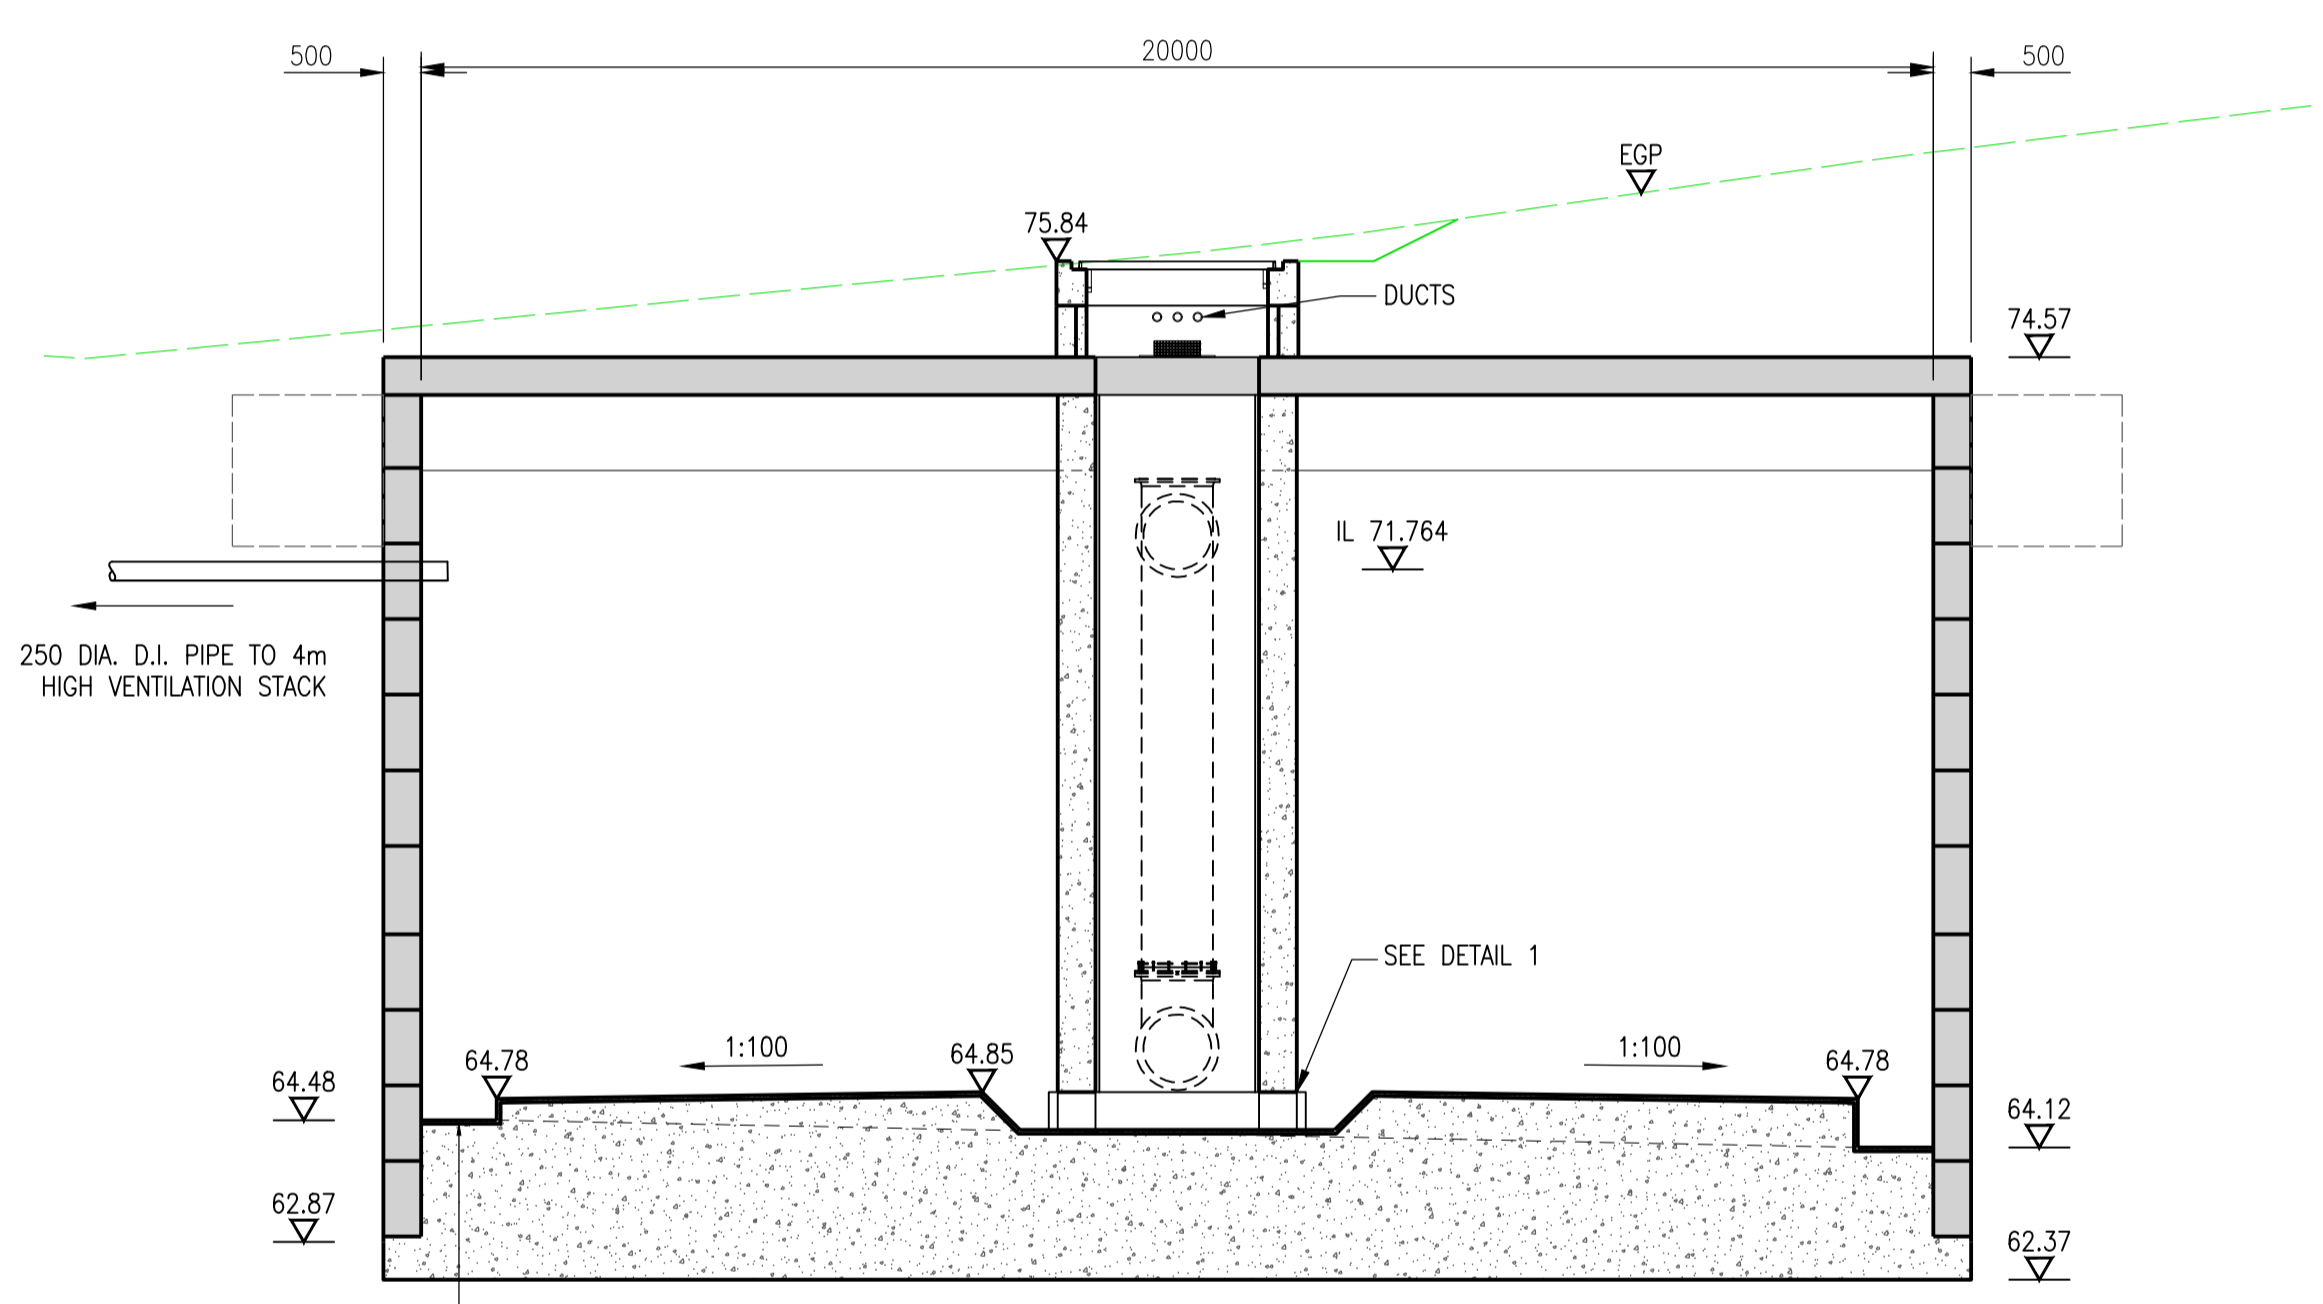


SECTION B-B


PIPE FITTINGS AND DETAILS  
 SUBJECT TO DETAILED DESIGN

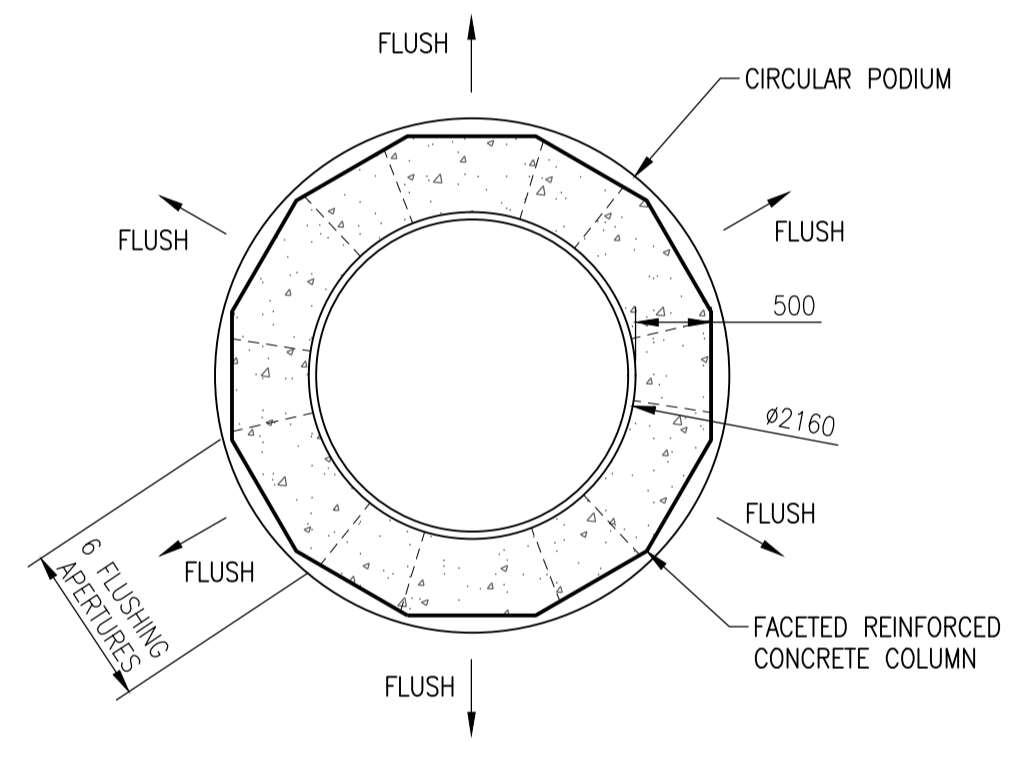








SECTIONAL PLAN  
 DETAIL 1

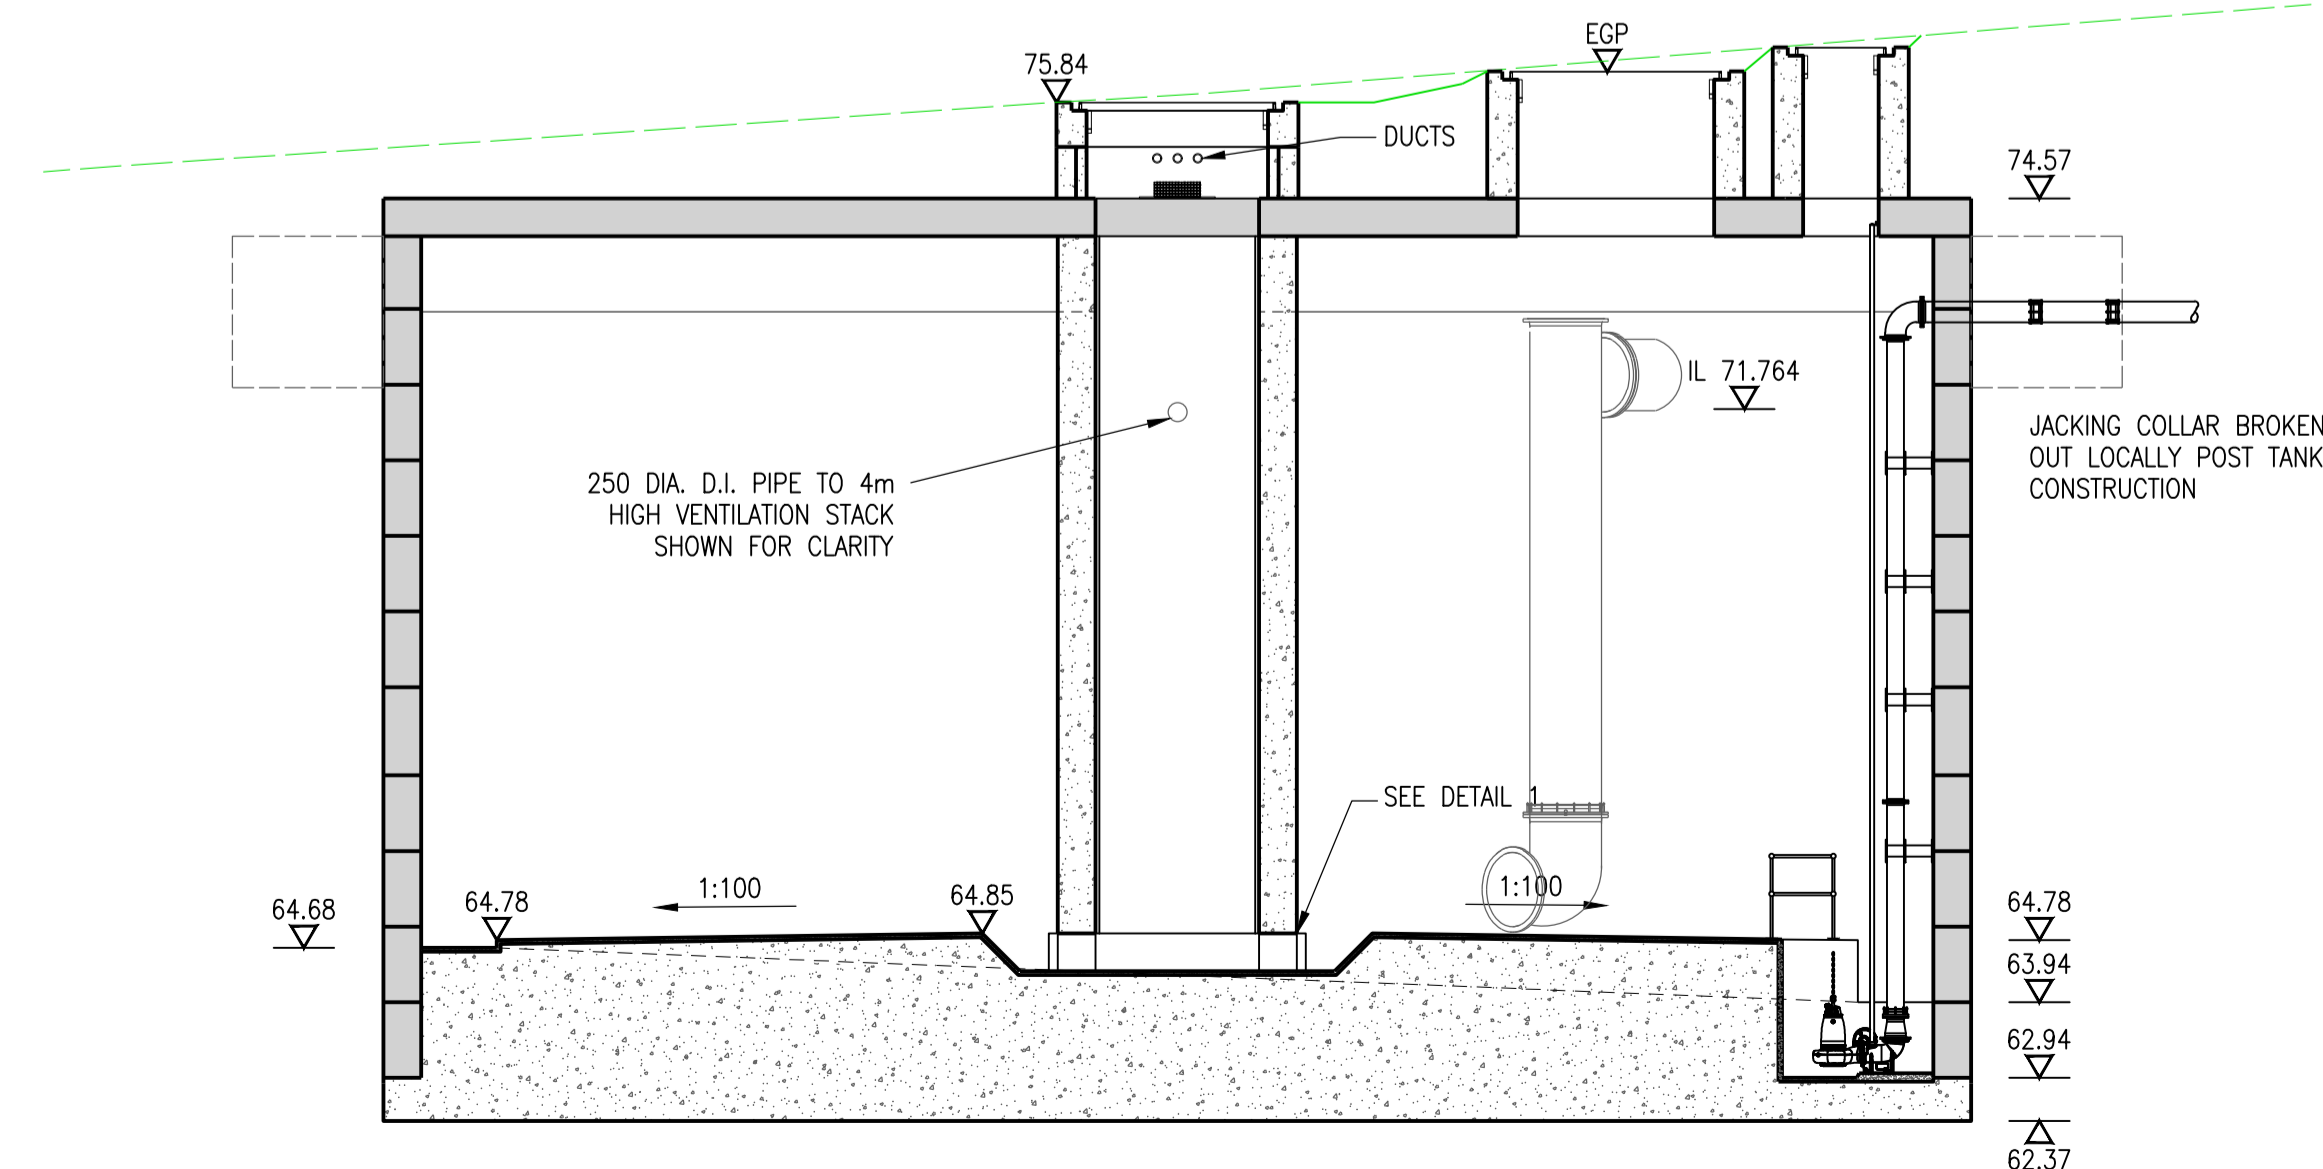

SECTION C-C

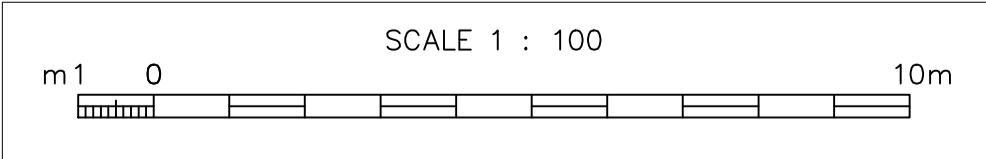

Notes:  
1. ALL DIMENSIONS IN METRES AND ALL LEVELS IN METRES AOD, UNLESS NOTED OTHERWISE.

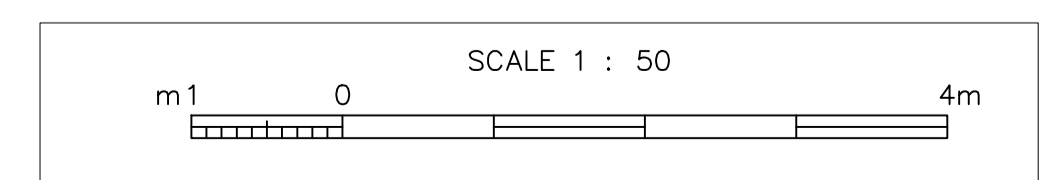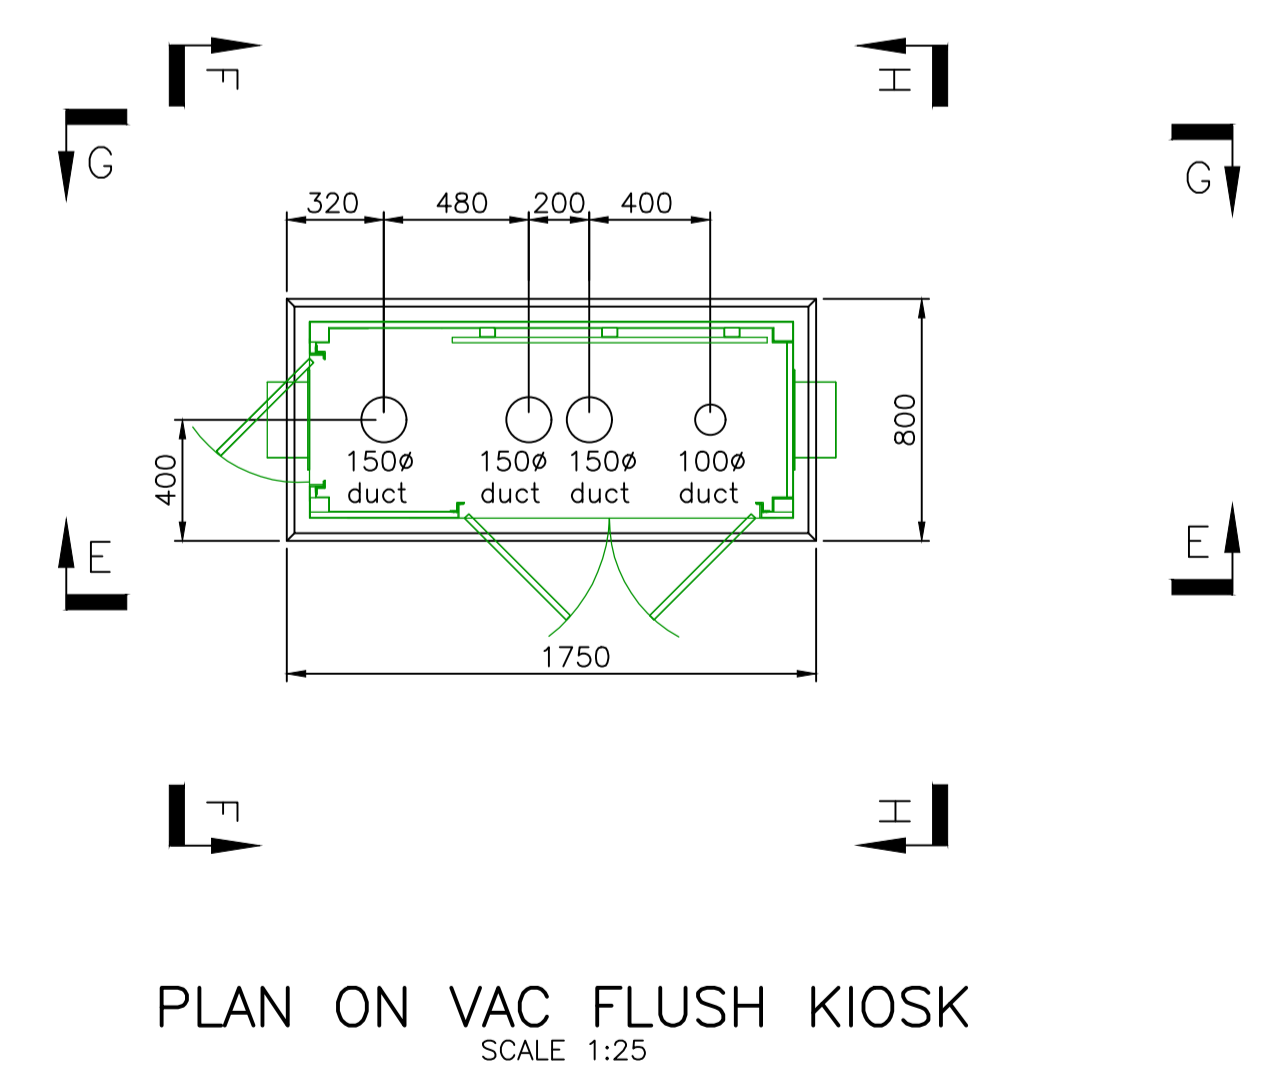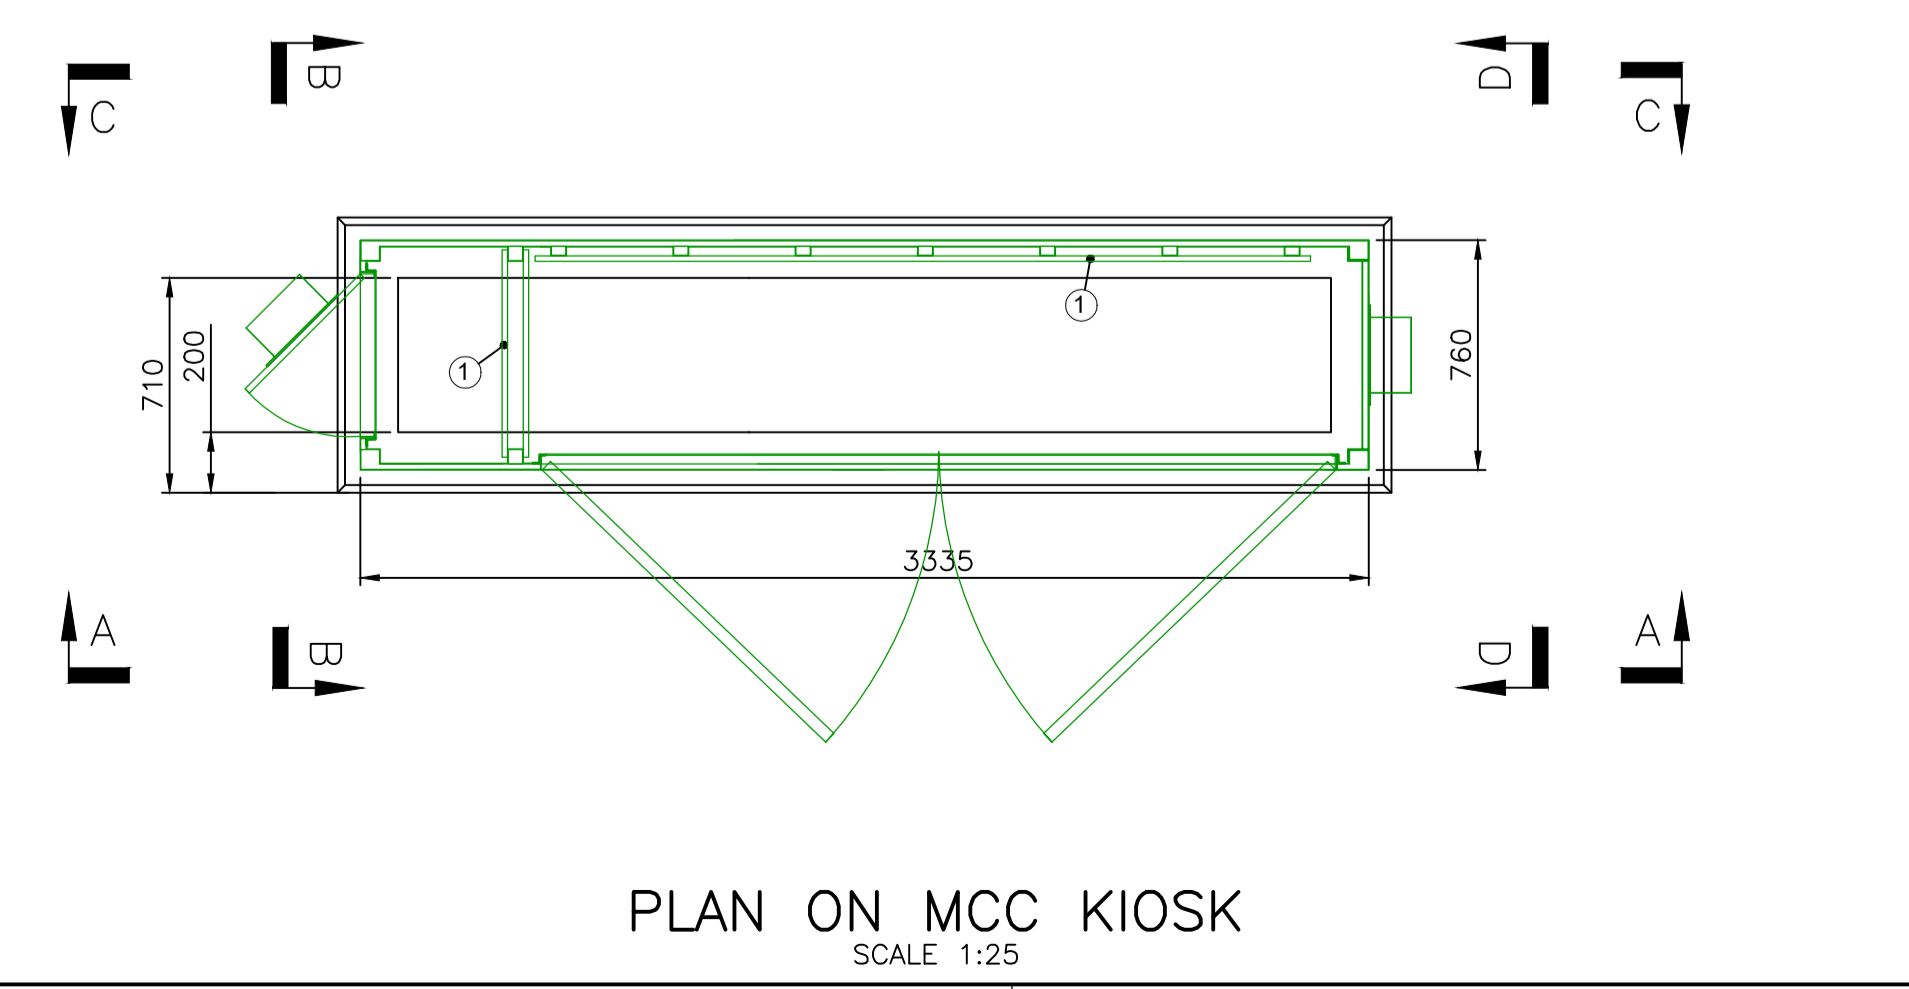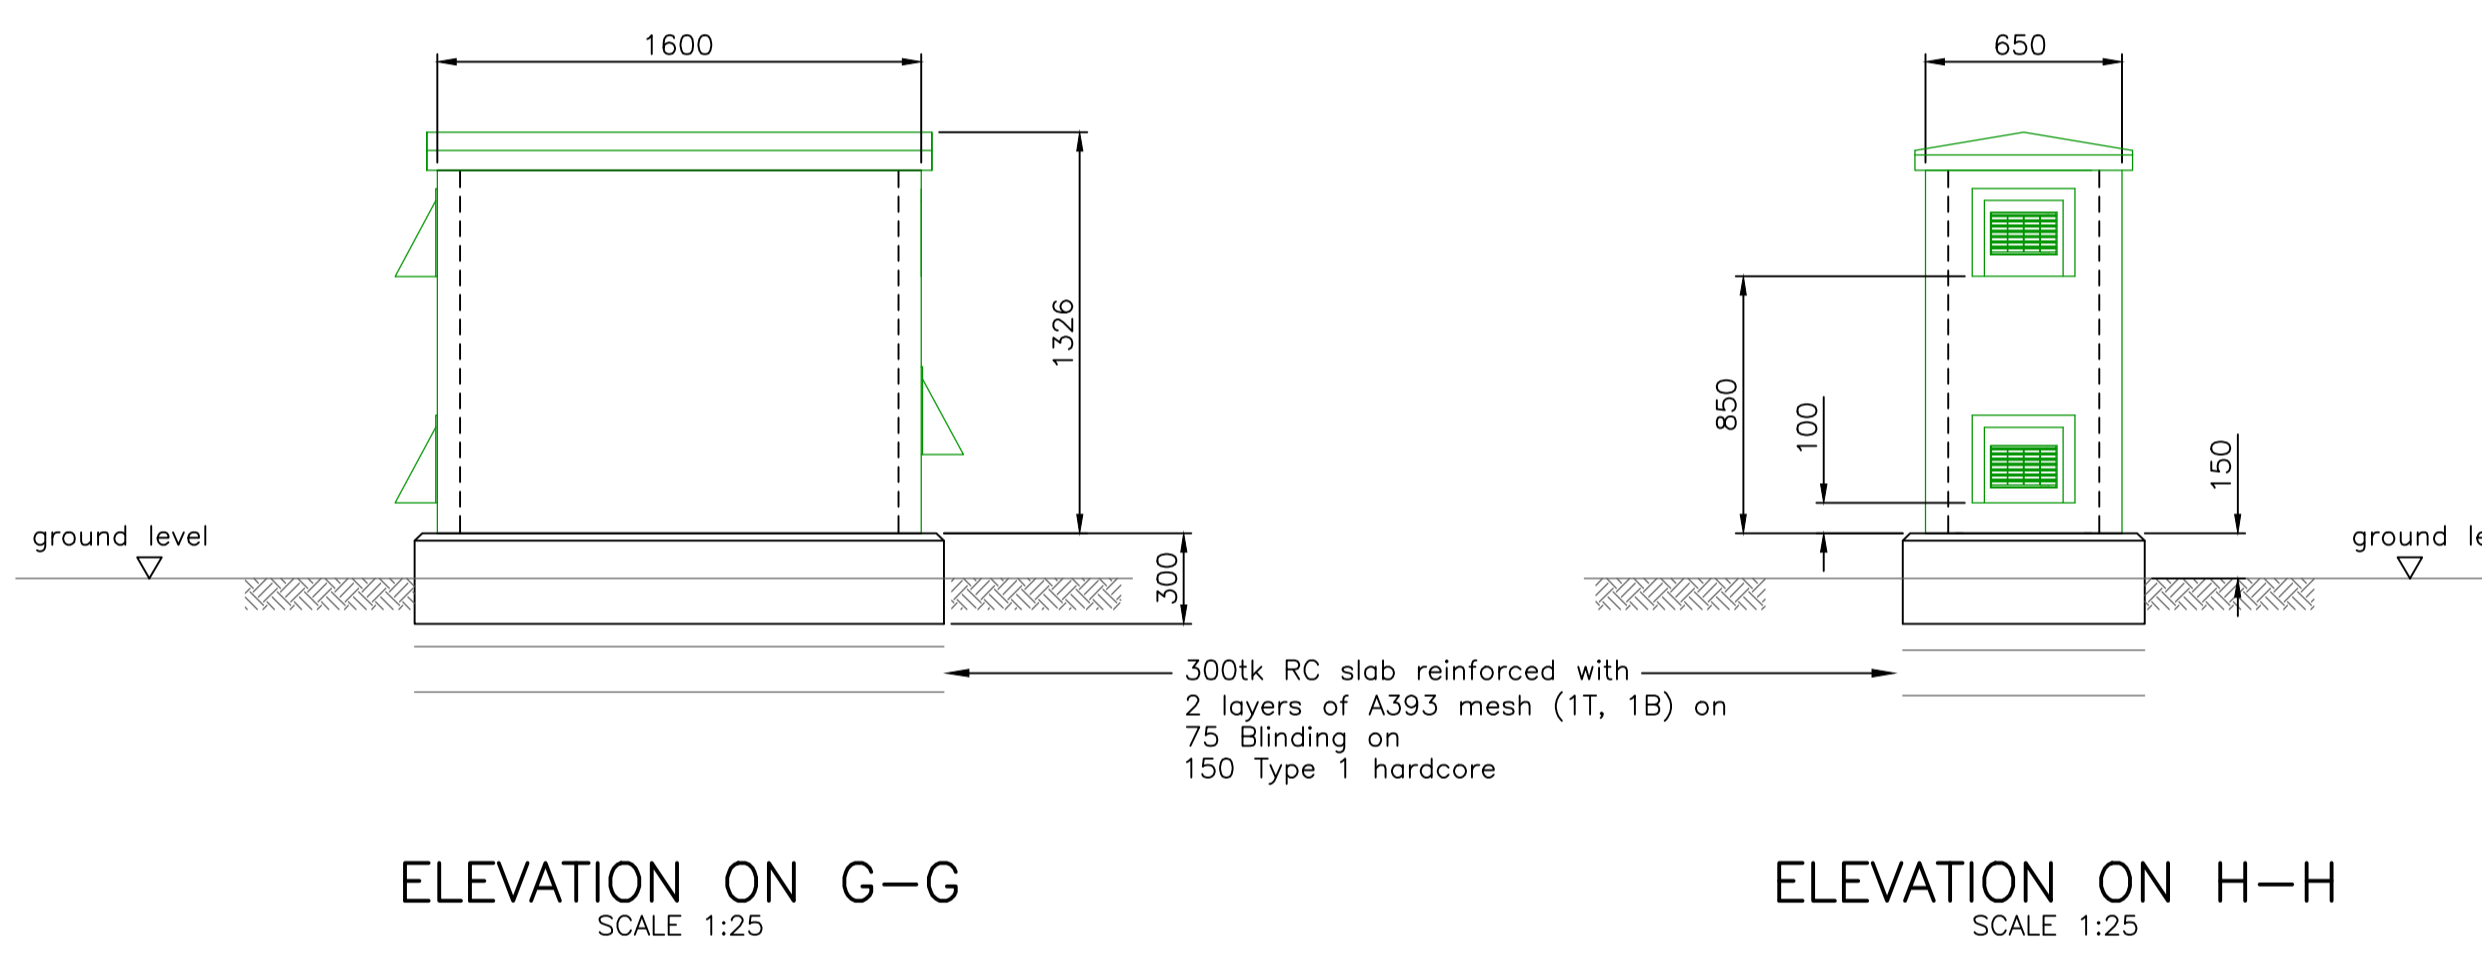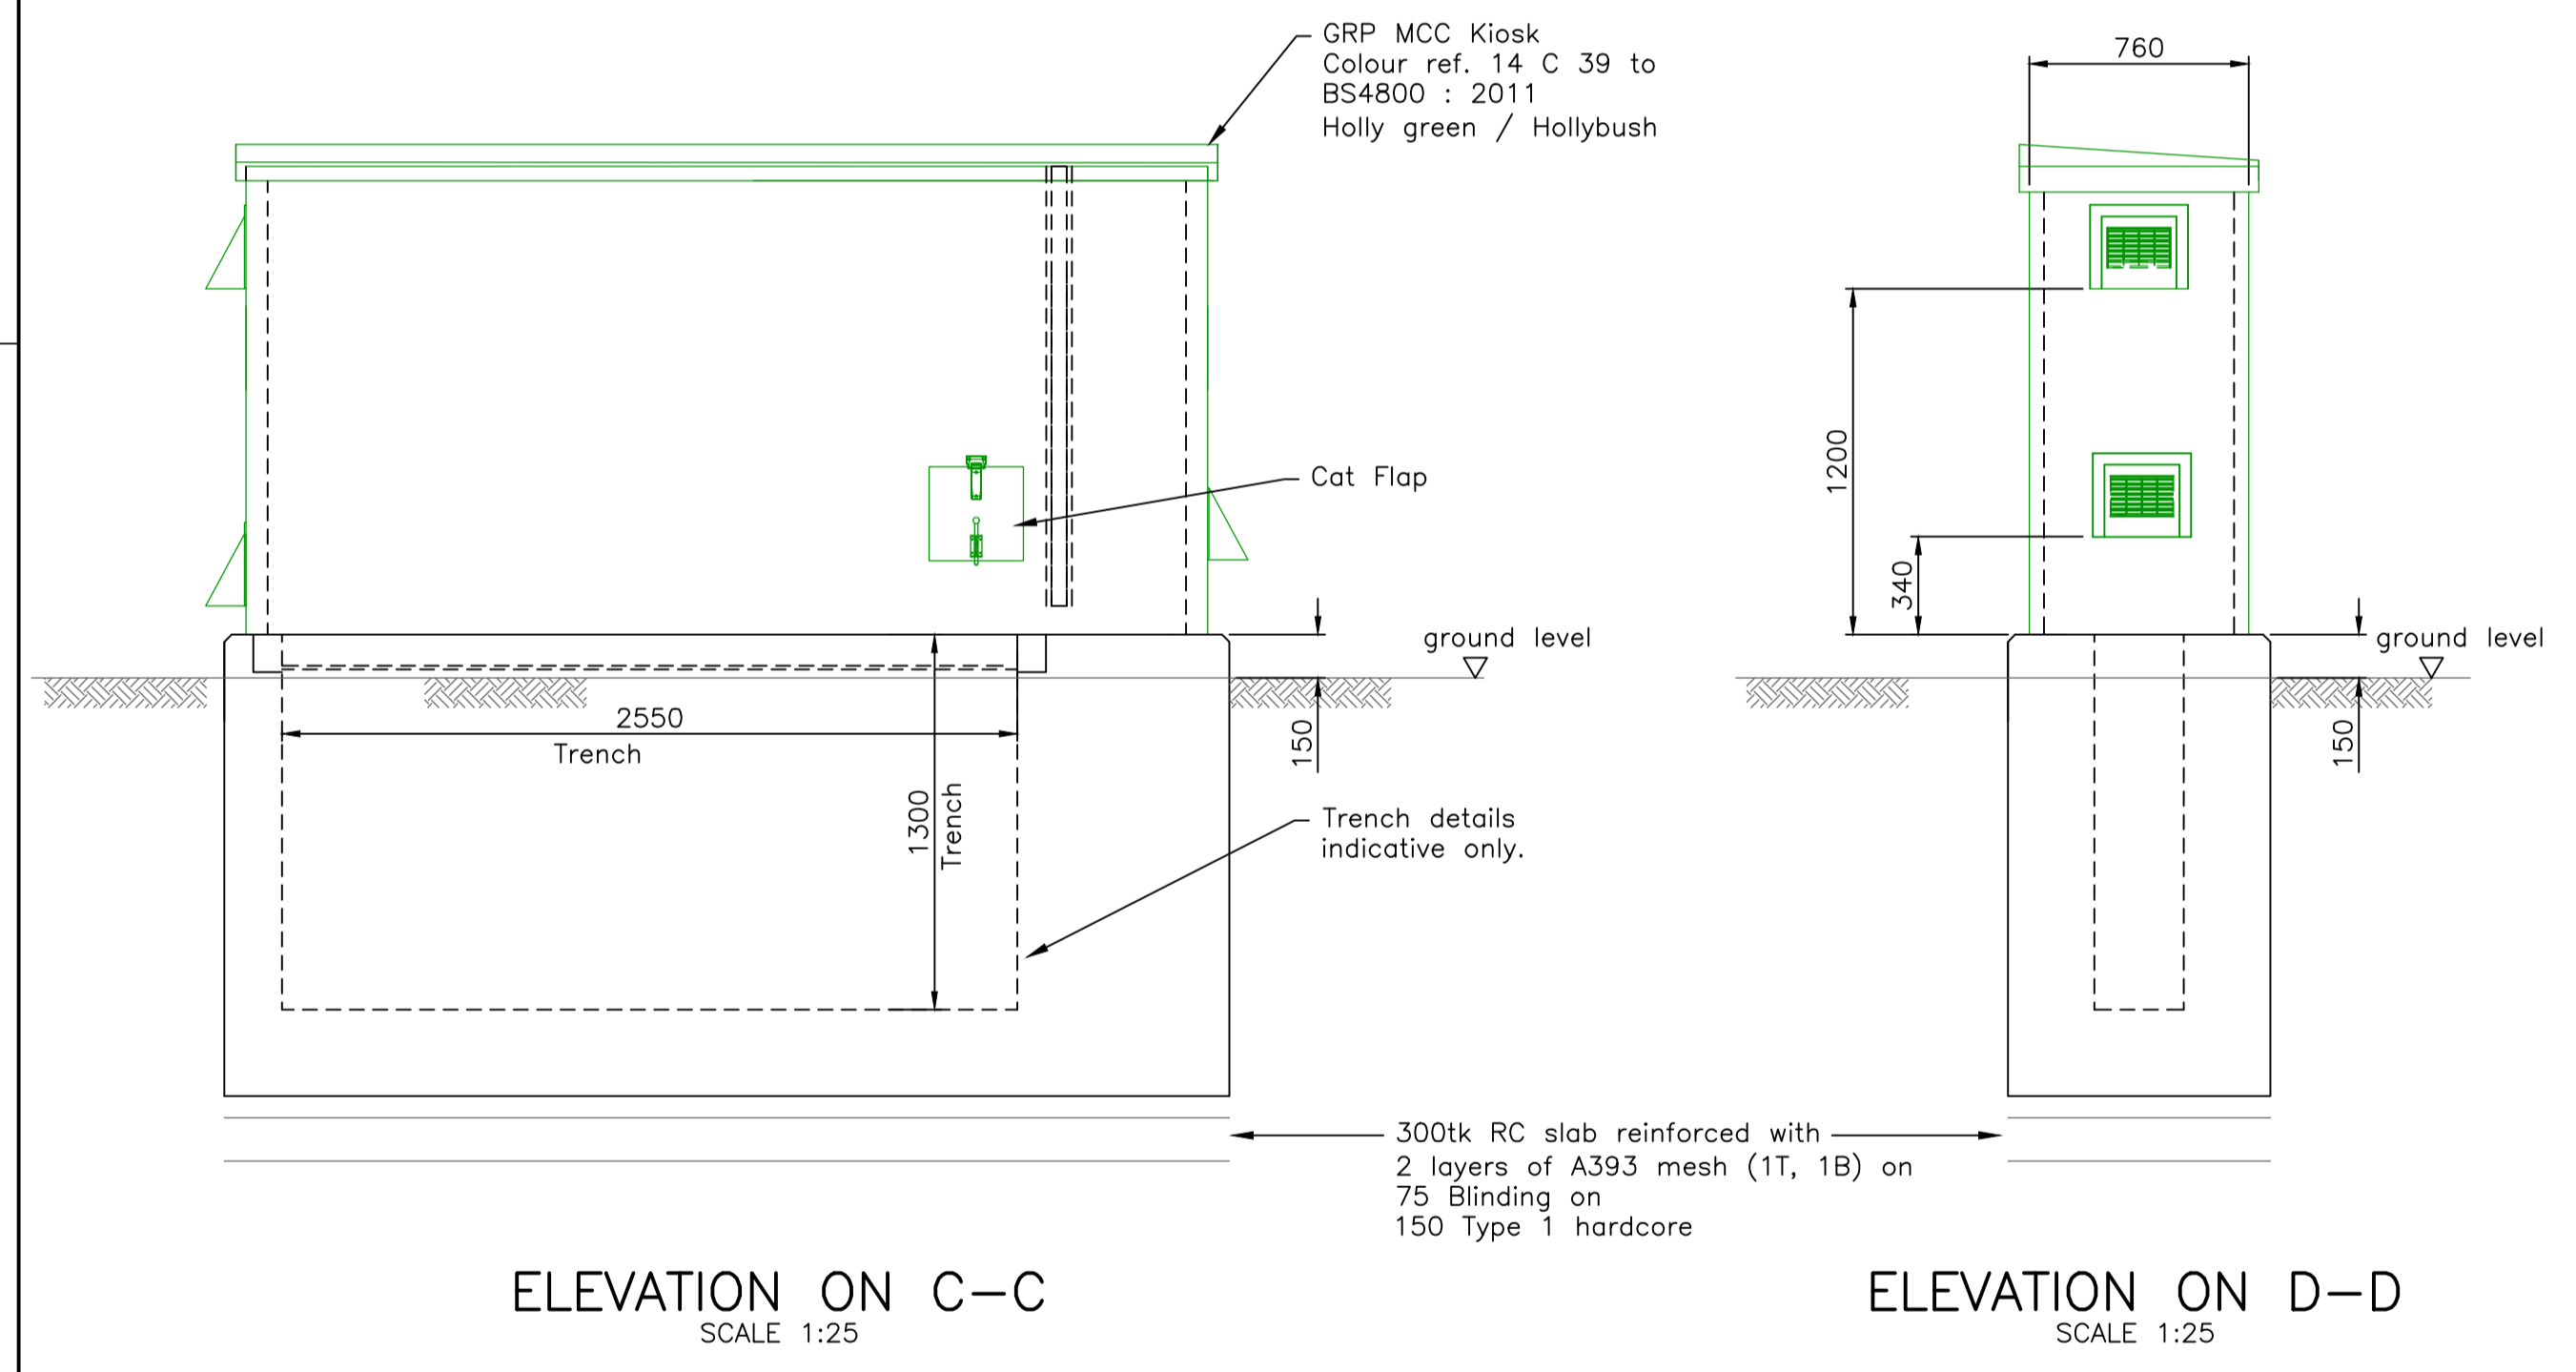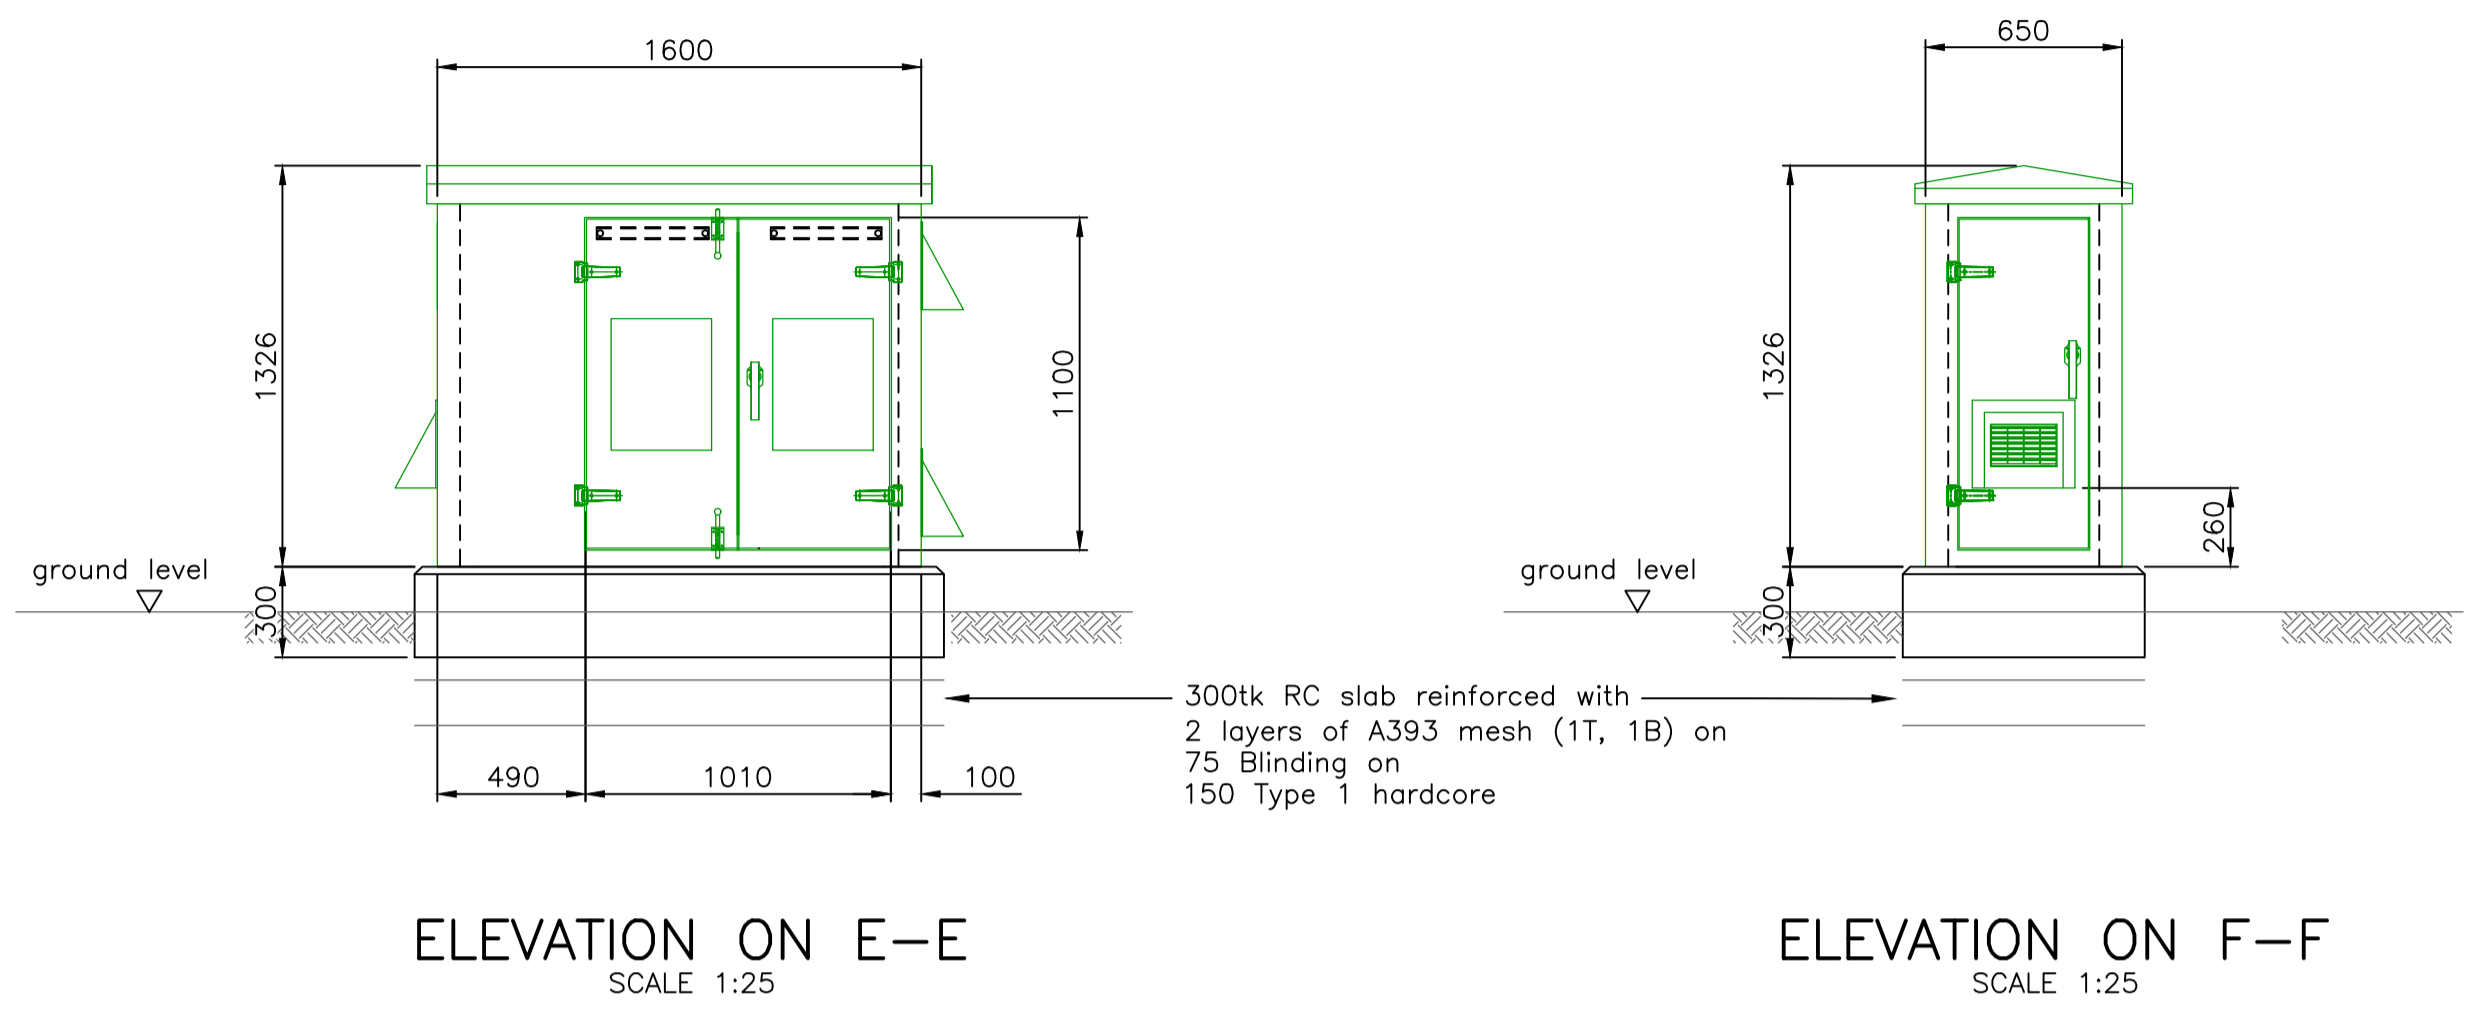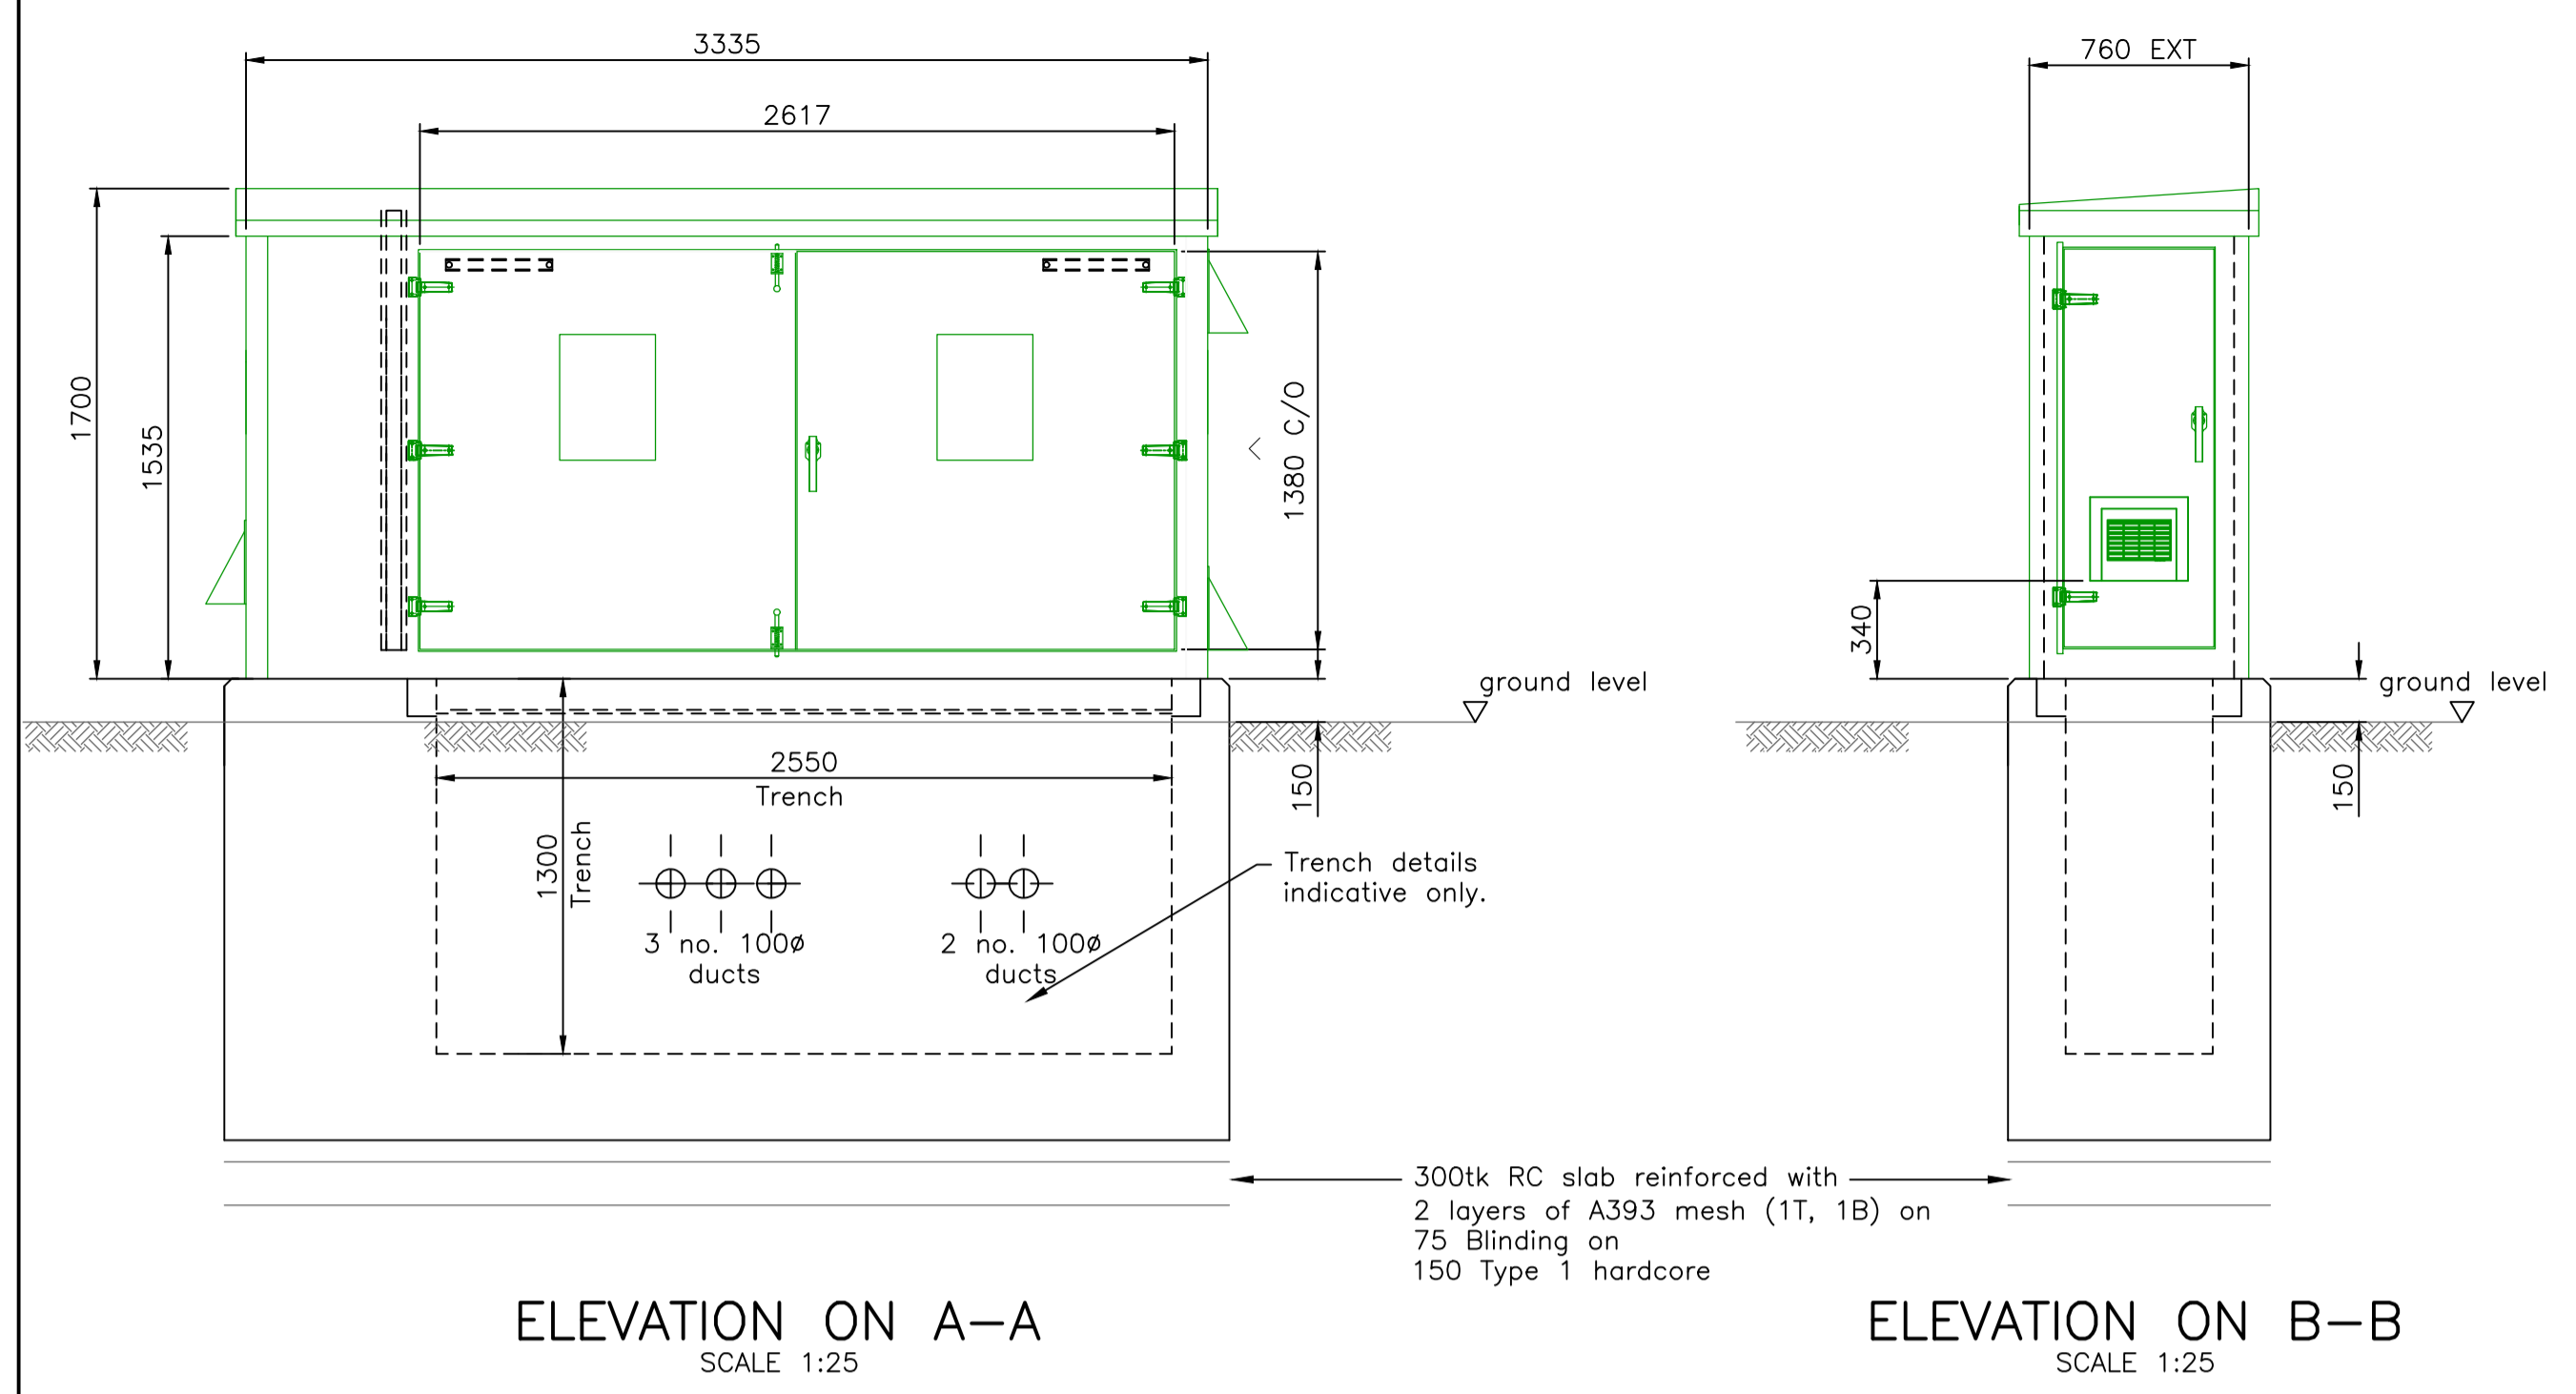

- REFERENCES:
- DOA0024560-SN-DRA-04000101
  - PROPOSED ATTENUATION TANK LOCATION PLAN FOR PLANNING DOA0024560-SN-DRA-04000102
  - PROPOSED ATTENUATION TANK SITE LAYOUT FOR PLANNING DOA0024560-SN-DRA-04000103
  - PROPOSED ATTENUATION TANK SITE ELEVATIONS FOR PLANNING DOA0024560-SN-DRA-04000104
  - PROPOSED ATTENUATION TANK PLANS FOR PLANNING DOA0024560-SN-DRA-04000105
  - PROPOSED ATTENUATION TANK SECTIONS FOR PLANNING DOA0024560-SN-DRA-04000106

Rev	Description	Drawn	Chk'd	App'd	Date
0D	For Information	SJF	GDH	GDH	01-Feb-22
0C	For Information	DJK	CMcN	GDH	18-Aug-21
0B	For Information	SJF	CMcN	CMcN	21-Jun-21
0A	For Information	SJF	CMcN	GDH	21-Jun-21

This drawing is the property of Scottish Water and must not be copied or used for any purpose other than that for which it is supplied without the written consent of Scottish Water.

**SCOTTISH WATER**  
CASTLE HOUSE  
6 CASTLE HOUSE  
CARNEGIE CAMPUS  
DUNFERMLINE  
FIFE KY11 8GG  
TEL: 01383 848200  
FAX: 01383 848371

CALEDONIA WATER ALLIANCE  
1<sup>st</sup> FLOOR, BUCHANAN TOWER  
BUCHANAN BUSINESS PARK  
CUMBERNAULD ROAD, STEPPS  
GLASGOW G3 6HZ  
TEL: 0141 212 6610

Originated By	Drawn By	Checked By	Approved By
SJF	SJF	CMcN	GDH
Date	Date	Date	Date
18-Jun-21	18-Jun-21	21-Jun-21	21-Jun-21
Scale	Status		
1:50	FOR INFORMATION		

Project Title  
**MARCHMONT ROAD  
WARRENDER PARK ROAD EDINBURGH**

Drawing Title  
**PROPOSED  
MCC & VACFLUSH KIOSK GA  
FOR PLANNING**

ELLIPSE EQUIPMENT No. AAAAAAAAAA  
ELLIPSE PLANT No. XXXXXXXXXX | AUTOCODE No. 503594  
Drawing No.  
**DOA0024560-SN-DRA-04000106-0D**